





UNION AVENUE SW SIDEWALK


TIB PROJECT NO. P-P-199(P11)-1

COL PROJECT NO. 302.0096

INDEX OF DRAWINGS

DRAWING	SHEET	DESCRIPTION
CV	1 OF 20	COVER SHEET
LA	2 OF 20	LEGENDS, ABBREVIATIONS, NOTES, AND SYMBOLS
AL	3 OF 20	ALIGNMENT PLAN
RS	4 OF 20	ROADWAY SECTIONS
SP-1	5 OF 20	SITE PREPARATION STA. 211+00 TO STA. 221+00
SP-2	6 OF 20	SITE PREPARATION STA. 221+00 TO STA. 231+00
SP-3	7 OF 20	SITE PREPARATION STA. 231+00 TO STA. 241+84
PP-1	8 OF 20	PLAN & PROFILE - STA. 211+00 TO STA. 216+00
PP-2	9 OF 20	PLAN & PROFILE - STA. 216+00 TO STA. 221+00
PP-3	10 OF 20	PLAN & PROFILE - STA. 221+00 TO STA. 226+00
PP-4	11 OF 20	PLAN & PROFILE - STA. 226+00 TO STA. 231+00
PP-5	12 OF 20	PLAN & PROFILE - STA. 231+00 TO STA. 236+00
PP-6	13 OF 20	PLAN & PROFILE - STA. 236+00 TO STA. 241+84
IC-1	14 OF 20	ILLUM./CHANNELIZATION PLAN - STA. 211+00 TO STA. 221+00
IC-2	15 OF 20	ILLUM./CHANNELIZATION PLAN - STA. 221+00 TO STA. 231+15
IC-3	16 OF 20	ILLUM./CHANNELIZATION PLAN - STA. 231+15 TO STA. 241+55
TC-1	17 OF 20	TRAFFIC CONTROL PLAN - EXTERIOR SIGNAGE
TC-2	18 OF 20	TRAFFIC CONTROL PLAN - STA. 204+00 TO STA. 216+50
TC-3	19 OF 20	TRAFFIC CONTROL PLAN - STA. 216+50 TO STA. 229+00
TC-4	20 OF 20	TRAFFIC CONTROL PLAN - STA. 229+00 TO STA. 241+50

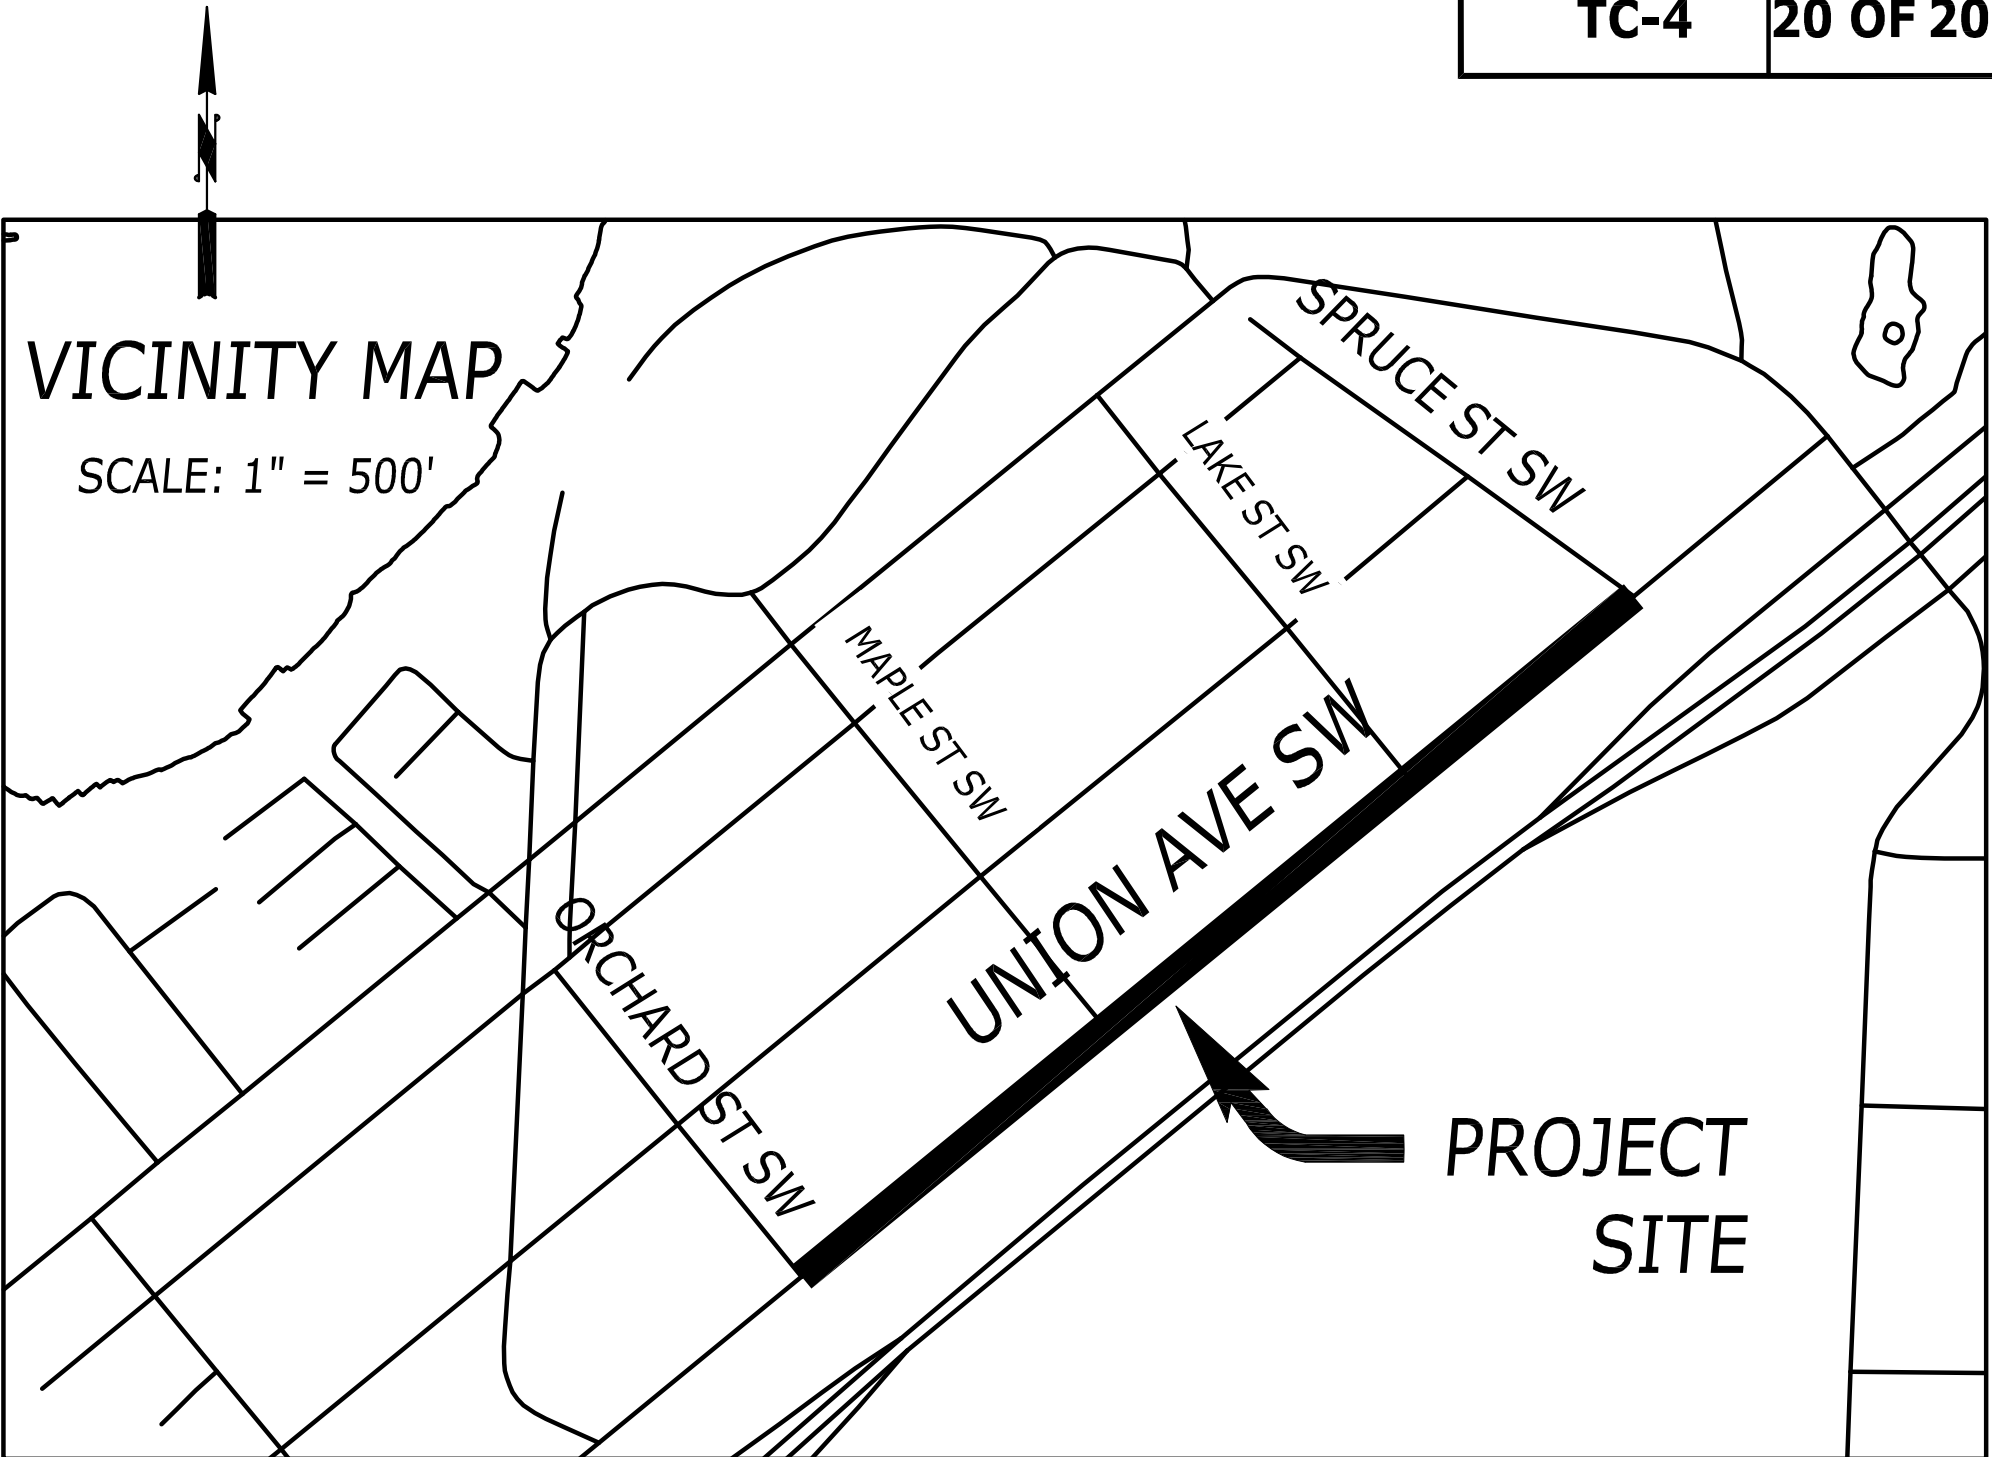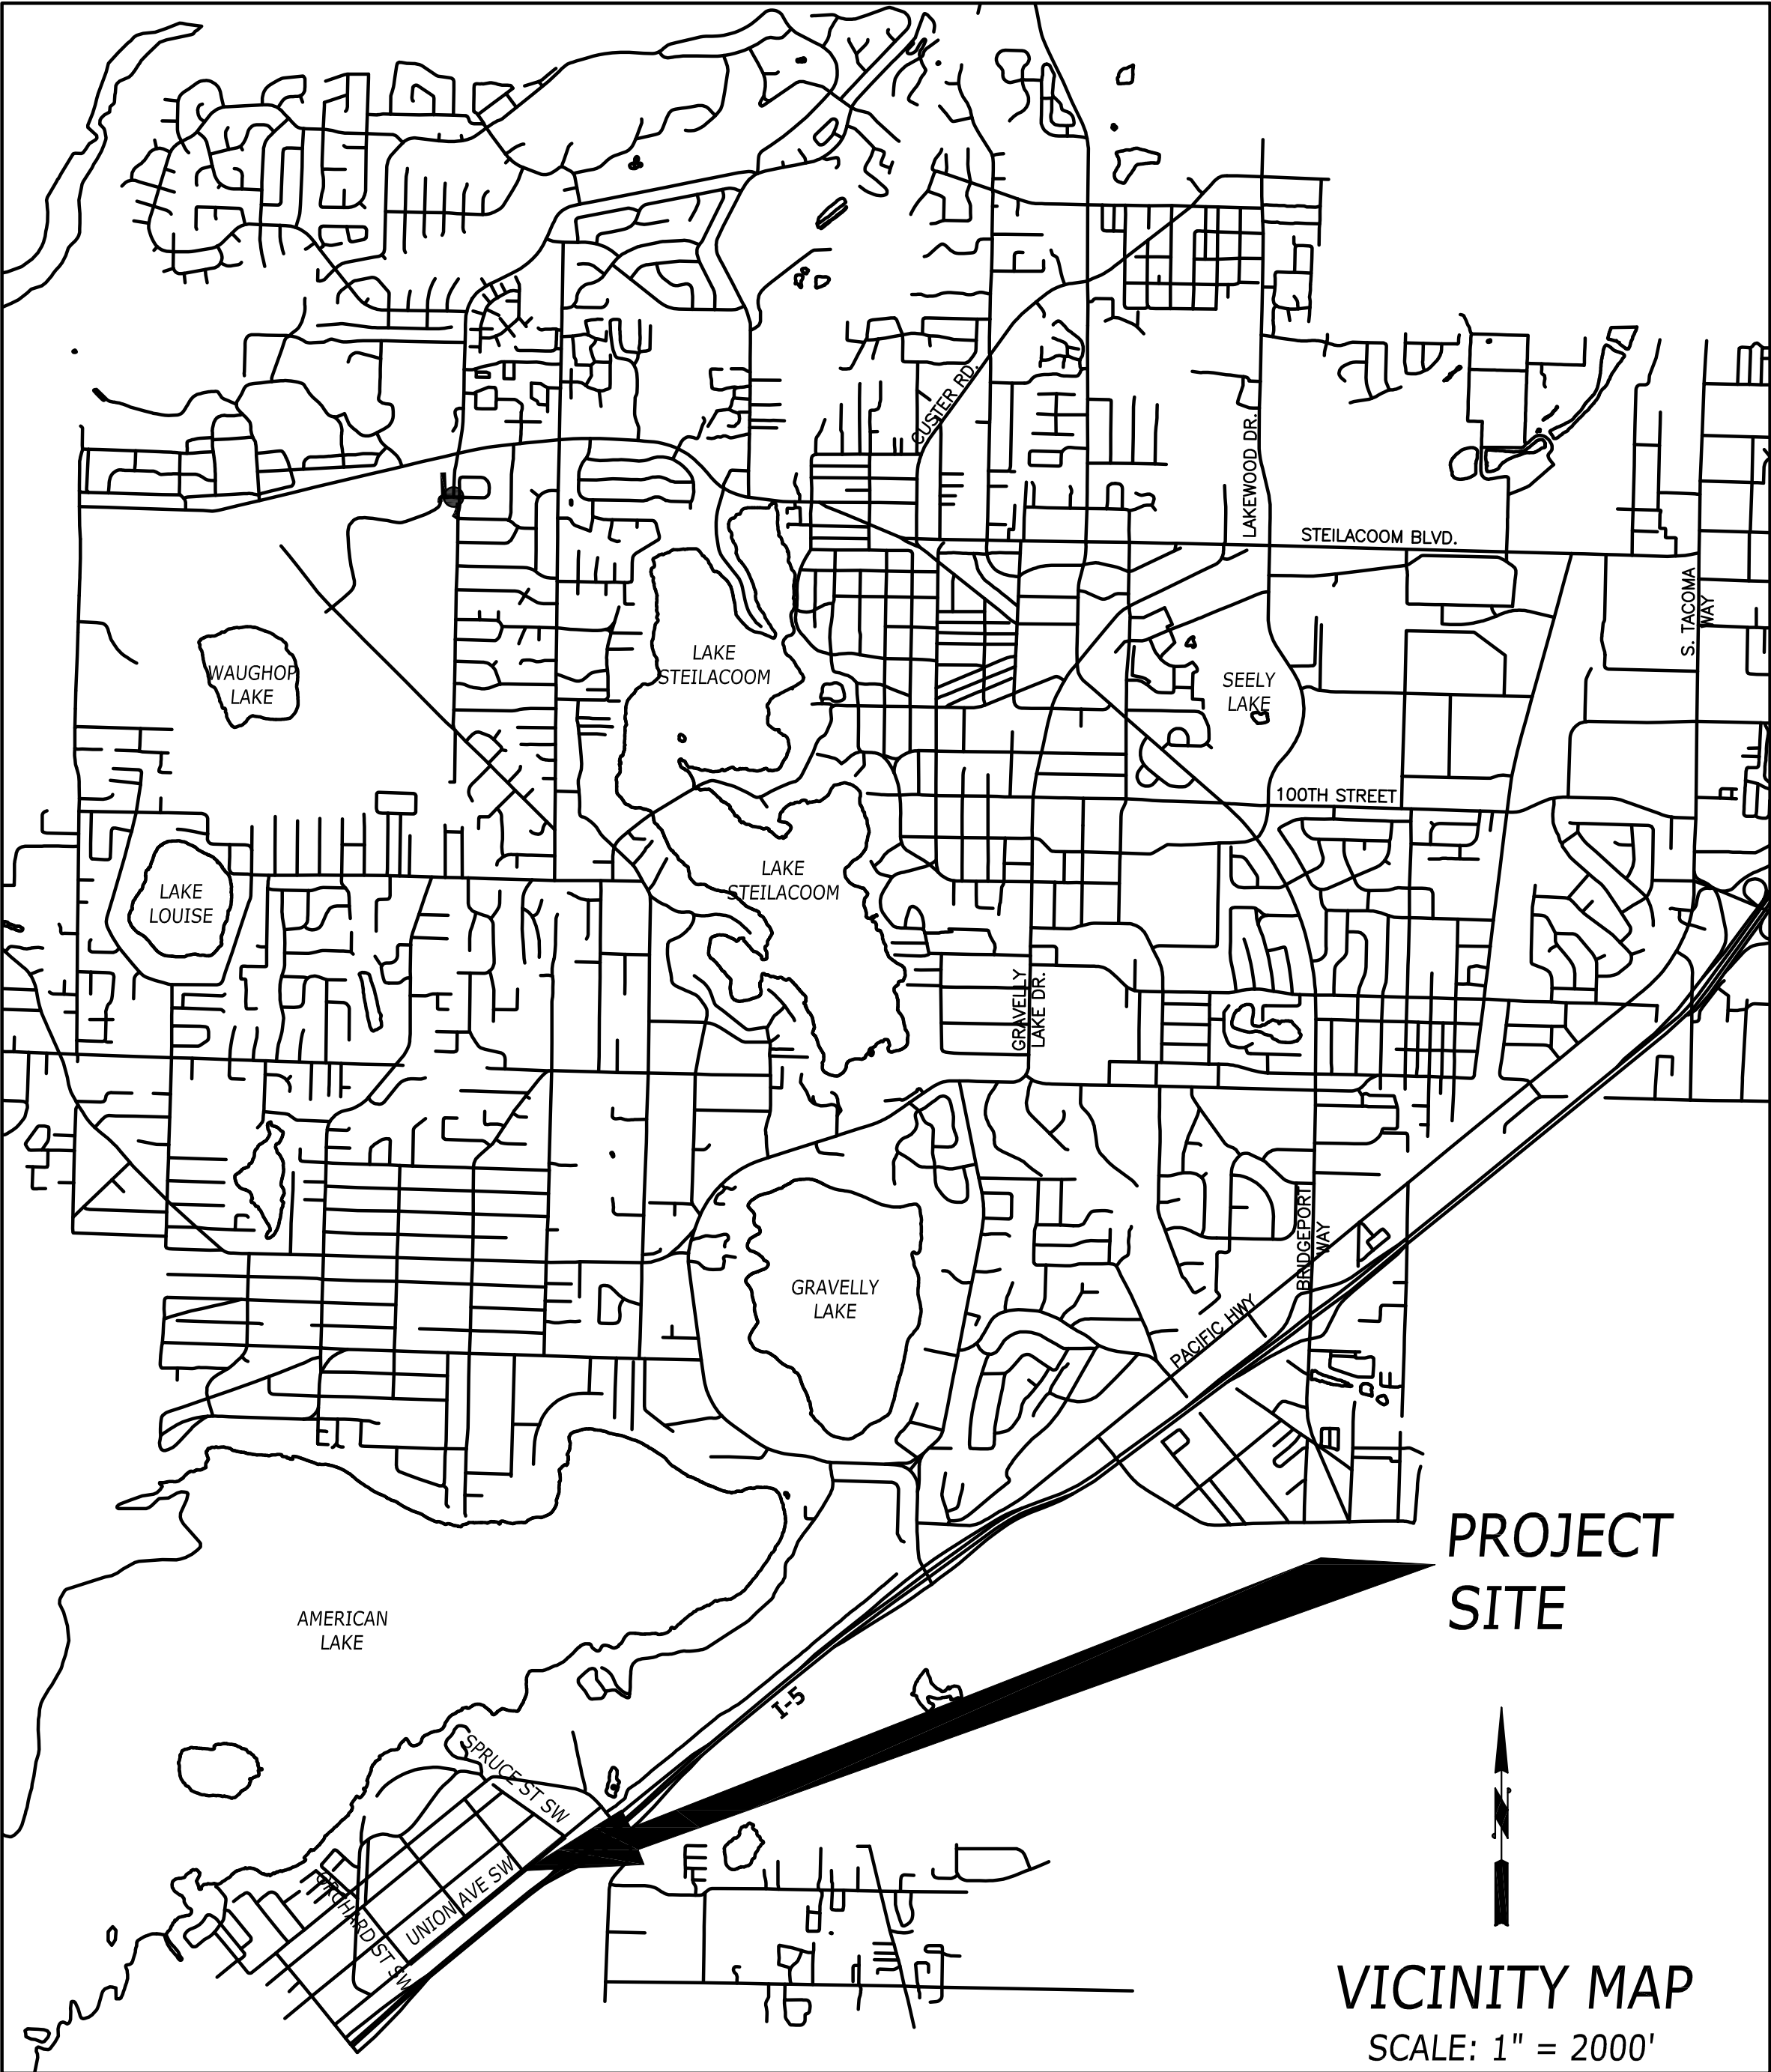

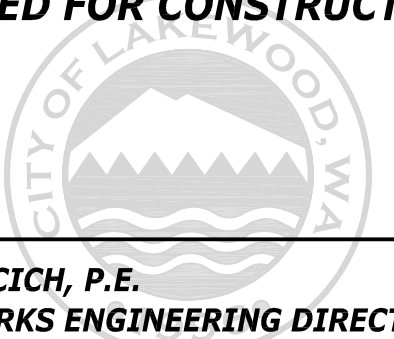No.	Release/Revision	Rel. Date	Rel. By	Designed By: T. POKSWINSKI	APPROVED FOR CONSTRUCTION  PAUL A. BUCICH, P.E. PUBLIC WORKS ENGINEERING DIRECTOR/CITY ENGINEER DATE	Project Name: UNION AVE SW IMPROVEMENTS	Job No. 302.0096
△				Entered By: A. DOBROVIDOVA			
△				Checked By: C. T. HILL			
△				Approved By: P. BUCICH			
△				Project Start Date: XX/XX/2023 Drawing Scale: AS SHOWN Electronic File Name: 302.0096		Drawing Name: COVER SHEET	Drawing No. CV
△							Sheet 1 of 20

WATER SYMBOLS <table><tr><th>EXIST.</th><th>PROP.</th><th>DESCRIPTION</th></tr><tr><td></td><td></td><td>BLOW-OFF ASSEMBLY</td></tr><tr><td></td><td></td><td>CAP/PLUG</td></tr><tr><td></td><td></td><td>COUPLING</td></tr><tr><td></td><td></td><td>REDUCER</td></tr><tr><td></td><td></td><td>THRUST BLOCK</td></tr><tr><td></td><td></td><td>WATER METER</td></tr><tr><td></td><td></td><td>FIRE HYDRANT</td></tr><tr><td></td><td></td><td>BUTTERFLY VALVE</td></tr><tr><td></td><td></td><td>GATE VALVE</td></tr><tr><td></td><td></td><td>AIR RELEASE VALVE</td></tr><tr><td></td><td></td><td>SPRINKLER HEAD</td></tr></table>				EXIST.	PROP.	DESCRIPTION			BLOW-OFF ASSEMBLY			CAP/PLUG			COUPLING			REDUCER			THRUST BLOCK			WATER METER			FIRE HYDRANT			BUTTERFLY VALVE			GATE VALVE			AIR RELEASE VALVE			SPRINKLER HEAD	SURFACE FEATURE /LANDSCAPE SYMBOLS <table><tr><th>EXIST.</th><th>PROP. /RELOCATE</th><th>DESCRIPTION</th></tr><tr><td></td><td></td><td>JUNCTION BOX (TYPE I, II, III)</td></tr><tr><td></td><td></td><td>MAILBOX</td></tr><tr><td></td><td></td><td>SCHOOL ZONE FLASHING LIGHT ASSEMBLY</td></tr><tr><td></td><td></td><td>SHRUB /HEDGE</td></tr><tr><td></td><td></td><td>STREET SIGN</td></tr><tr><td></td><td></td><td>STREET LIGHT ASSEMBLY</td></tr><tr><td></td><td></td><td>TRAFFIC SIGN POST</td></tr><tr><td></td><td></td><td>TRAFFIC BARRIER GUARDRAIL</td></tr><tr><td></td><td></td><td>TREE (CONIFEROUS)</td></tr><tr><td></td><td></td><td>TREE (DECIDUOUS)</td></tr></table>				EXIST.	PROP. /RELOCATE	DESCRIPTION			JUNCTION BOX (TYPE I, II, III)			MAILBOX			SCHOOL ZONE FLASHING LIGHT ASSEMBLY			SHRUB /HEDGE			STREET SIGN			STREET LIGHT ASSEMBLY			TRAFFIC SIGN POST			TRAFFIC BARRIER GUARDRAIL			TREE (CONIFEROUS)			TREE (DECIDUOUS)	CHANNELIZATION SYMBOLS <table><tr><th>EXISTING</th><th>PROPOSED</th><th>DESCRIPTION</th></tr><tr><td></td><td></td><td>LEFT TURN ARROW</td></tr><tr><td></td><td></td><td>RIGHT TURN ARROW</td></tr><tr><td></td><td></td><td>STRAIGHT ARROW</td></tr><tr><td></td><td></td><td>STRAIGHT/LEFT ARROW</td></tr><tr><td></td><td></td><td>STRAIGHT/RIGHT ARROW</td></tr><tr><td></td><td></td><td>ONLY</td></tr><tr><td></td><td></td><td>STOP</td></tr><tr><td></td><td></td><td>YIELD</td></tr></table>				EXISTING	PROPOSED	DESCRIPTION			LEFT TURN ARROW			RIGHT TURN ARROW			STRAIGHT ARROW			STRAIGHT/LEFT ARROW			STRAIGHT/RIGHT ARROW			ONLY			STOP			YIELD	EROSION CONTROL CONSTRUCTION ENTRANCE SILT FENCE INLET PROTECTION EROSION CONTROL GENERAL NOTES 1. PRIOR TO COMMENCING CONSTRUCTION, THE CONTRACTOR SHALL INSTALL ALL BMPs AS SHOWN ON THESE PLANS OR DETERMINED BY THE ENGINEER IN THE FIELD, TO MINIMIZE EROSION AND PREVENT SEDIMENT FROM ENTERING THE STORM SYSTEM. 2. THE CONTRACTOR IS RESPONSIBLE FOR CONTAINING SEDIMENT AND DEBRIS FROM ENTERING THE STORMWATER SYSTEM. IF THE BMPs SHOWN ON THE PLAN ARE FOUND TO BE INSUFFICIENT, THE CONTRACTOR SHALL INSTALL ADDITIONAL BMPs TO ELIMINATE CONSTRUCTION STORMWATER POLLUTION. 3. THE CONTRACTOR SHALL NOTIFY THE ENGINEER IMMEDIATELY IN THE EVENT THAT THE CONTRACTOR DISCOVERS CONDITIONS OR ACTIVITIES THAT WILL DIMINISH THE WATER QUALITY DOWNSTREAM.			
EXIST.	PROP.	DESCRIPTION																																																																																																													
		BLOW-OFF ASSEMBLY																																																																																																													
		CAP/PLUG																																																																																																													
		COUPLING																																																																																																													
		REDUCER																																																																																																													
		THRUST BLOCK																																																																																																													
		WATER METER																																																																																																													
		FIRE HYDRANT																																																																																																													
		BUTTERFLY VALVE																																																																																																													
		GATE VALVE																																																																																																													
		AIR RELEASE VALVE																																																																																																													
		SPRINKLER HEAD																																																																																																													
EXIST.	PROP. /RELOCATE	DESCRIPTION																																																																																																													
		JUNCTION BOX (TYPE I, II, III)																																																																																																													
		MAILBOX																																																																																																													
		SCHOOL ZONE FLASHING LIGHT ASSEMBLY																																																																																																													
		SHRUB /HEDGE																																																																																																													
		STREET SIGN																																																																																																													
		STREET LIGHT ASSEMBLY																																																																																																													
		TRAFFIC SIGN POST																																																																																																													
		TRAFFIC BARRIER GUARDRAIL																																																																																																													
		TREE (CONIFEROUS)																																																																																																													
		TREE (DECIDUOUS)																																																																																																													
EXISTING	PROPOSED	DESCRIPTION																																																																																																													
		LEFT TURN ARROW																																																																																																													
		RIGHT TURN ARROW																																																																																																													
		STRAIGHT ARROW																																																																																																													
		STRAIGHT/LEFT ARROW																																																																																																													
		STRAIGHT/RIGHT ARROW																																																																																																													
		ONLY																																																																																																													
		STOP																																																																																																													
		YIELD																																																																																																													
SANITARY /STORM SEWER SYMBOLS <table><tr><th>EXIST.</th><th>PROP.</th><th>DESCRIPTION</th></tr><tr><td></td><td></td><td>SANITARY SEWER CLEANOUT</td></tr><tr><td></td><td></td><td>SANITARY SEWER MANHOLE</td></tr><tr><td></td><td></td><td>STORM DRAIN CATCH BASIN, TYPE I</td></tr><tr><td></td><td></td><td>STORM DRAIN CATCH BASIN, TYPE II</td></tr><tr><td></td><td></td><td>STORM DRAIN CATCH BASIN, TYPE II 48" OF BIGGER</td></tr><tr><td></td><td></td><td>STORM DRAIN CULVERT</td></tr><tr><td></td><td></td><td>DRAINAGE DITCH</td></tr><tr><td></td><td></td><td>DRY WELL</td></tr></table>				EXIST.	PROP.	DESCRIPTION			SANITARY SEWER CLEANOUT			SANITARY SEWER MANHOLE			STORM DRAIN CATCH BASIN, TYPE I			STORM DRAIN CATCH BASIN, TYPE II			STORM DRAIN CATCH BASIN, TYPE II 48" OF BIGGER			STORM DRAIN CULVERT			DRAINAGE DITCH			DRY WELL	GAS /POWER /TELEPHONE SYMBOLS <table><tr><th>EXIST.</th><th>PROP.</th><th>DESCRIPTION</th></tr><tr><td></td><td></td><td>GAS VALVE</td></tr><tr><td></td><td></td><td>UTILITY POLE</td></tr><tr><td></td><td></td><td>UTILITY POLE ANCHOR</td></tr><tr><td></td><td></td><td>TELEPHONE RISER</td></tr><tr><td></td><td></td><td>TELEPHONE VAULT</td></tr><tr><td></td><td></td><td>PAD MOUNTED TRANSFORMER</td></tr><tr><td></td><td></td><td>POLE MOUNTED TRANSFORMER</td></tr><tr><td></td><td></td><td>POWER VAULT</td></tr></table>				EXIST.	PROP.	DESCRIPTION			GAS VALVE			UTILITY POLE			UTILITY POLE ANCHOR			TELEPHONE RISER			TELEPHONE VAULT			PAD MOUNTED TRANSFORMER			POLE MOUNTED TRANSFORMER			POWER VAULT	GENERAL NOTES 1. ALL CURB RETURN ELEVATIONS SHOWN ON PLANS ARE TOP OF CURB AND DO NOT ACCOUNT FOR CURB RAMPS. ALL TOP OF CURB ELEVATIONS SHOWN REFLECT FULL 6" CURB HEIGHT AND DO NOT ACCOUNT FOR DEPRESSED CURB AT DRIVEWAY.																																																	
EXIST.	PROP.	DESCRIPTION																																																																																																													
		SANITARY SEWER CLEANOUT																																																																																																													
		SANITARY SEWER MANHOLE																																																																																																													
		STORM DRAIN CATCH BASIN, TYPE I																																																																																																													
		STORM DRAIN CATCH BASIN, TYPE II																																																																																																													
		STORM DRAIN CATCH BASIN, TYPE II 48" OF BIGGER																																																																																																													
		STORM DRAIN CULVERT																																																																																																													
		DRAINAGE DITCH																																																																																																													
		DRY WELL																																																																																																													
EXIST.	PROP.	DESCRIPTION																																																																																																													
		GAS VALVE																																																																																																													
		UTILITY POLE																																																																																																													
		UTILITY POLE ANCHOR																																																																																																													
		TELEPHONE RISER																																																																																																													
		TELEPHONE VAULT																																																																																																													
		PAD MOUNTED TRANSFORMER																																																																																																													
		POLE MOUNTED TRANSFORMER																																																																																																													
		POWER VAULT																																																																																																													
ABBREVIATIONS ABAND. ABANDON ACP ASPHALT CONCRETE PVMNT. AP ANGLE POINT APPROX. APPROXIMATELY ASPH. ASPHALT AVE AVENUE BOT. BOTTOM BLDG. BUILDING BLVD. BOULEVARD BSW BACK OF SIDEWALK CB CATCH BASIN CDF CONTROLLED DENSITY FILL CL CENTERLINE CO CLEAN OUT CONC. CONCRETE CONT. CONTINUE CMP CORRUGATED METAL PIPE CPE CORRUGATED POLYETYLENE PIPE CR CROWN CSTC CRUSHED SURFACING TOP COURSE CU.FT. CUBIC FEET CU.YD. CUBIC YARD DEG. DEGREE DBL. DOUBLE DI DUCTILE DRWY DRIVEWAY E EAST EA EACH EG EDGE OF GRAVEL EL ELEVATION EP EDGE OF PAVEMENT EXC. EXCAVATION EX_EXIST... EXISTING FH FIRE HYDRANT FT FOOT FL FLANGED JOINT G GAS GV GAS VALVE GE GRATE ELEVATION GRVL ... GRAVEL HORIZ. . HORIZONTAL HMA HOT MIX ASPHALT HPG HIGH PRESSURE GAS IE INVERT ELEVATION IRR. IRRIGATION L LENGTH LT LEFT MH MANHOLE MJ MECHANICAL JOINT MAX. ... MAXIMUM MIN. MINIMUM MISC. ... MISCELLANEOUS MON. ... MONUMENT N NORTH NTS NOT TO SCALE N.U. NOT USED O.C. ON CENTER PVMT. . PAVEMENT PED. ... PEDESTRIAN PL PROPERTY LINE PC POINT OF CURVE PT POINT OF TANGENT PI POINT OF INTERSECTION PROP. . PROPOSED PVC. POINT OF VERTICAL CURVE PVC POLY VINYL CHLORIDE PVI POINT OF VERT. INTERSECTION PVT POINT OF VERTICAL TANGENT R RADIUS RCP REINFORCED CONCRETE PIPE RT RIGHT R/W RIGHT-OF-WAY RD. ROAD S SOUTH SS SANITARY SEWER SAN. SANITARY SD STORM DRAIN SDMH STORM DRAIN MANHOLE S/W SIDEWALK SPECS. . SPECIFICATIONS STD. STANDARD STA. STATION ST. STREET T TELEPHONE T.B.C. TOP BACK OF CURB T.O.C. TOP OF CURB TYP. TYPICAL U.P. UTILITY POLE UNK. UNKNOWN V VALVE VAP VERTICAL ANGLE POINT V.C. VERTICAL CURVE VERT. ... VERTICAL W WEST WM WATER METER W.M. WILLAMETTE MERIDIAN W.V. WATER VALVE W/ WITH Z ZONE				LINE TYPES LEGEND <table><tr><th>EXIST.</th><th>PROP.</th><th>DESCRIPTION</th></tr><tr><td></td><td></td><td>BUILDING LINE</td></tr><tr><td></td><td></td><td>CABLE TELEVISION (OVERHEAD)</td></tr><tr><td></td><td></td><td>CABLE TELEVISION (UNDERGROUND)</td></tr><tr><td></td><td></td><td>CONDUIT</td></tr><tr><td></td><td></td><td>CONSTRUCTION CENTERLINE</td></tr><tr><td></td><td></td><td>EDGE OF SIDEWALK</td></tr><tr><td></td><td></td><td>EXISTING CROWN</td></tr><tr><td></td><td></td><td>FENCE BARBED WIRE</td></tr><tr><td></td><td></td><td>FENCE CHAIN LINK</td></tr><tr><td></td><td></td><td>FENCE WOOD</td></tr><tr><td></td><td></td><td>FIBER OPTIC AERIAL</td></tr><tr><td></td><td></td><td>FIBER OPTIC UNDERGROUND</td></tr><tr><td></td><td></td><td>INFILTRATION PIPE</td></tr><tr><td></td><td></td><td>GAS</td></tr><tr><td></td><td></td><td>HIGH PRESSURE GAS</td></tr><tr><td></td><td></td><td>POWER (OVERHEAD)</td></tr><tr><td></td><td></td><td>POWER (UNDERGROUND)</td></tr><tr><td></td><td></td><td>PROJECT LIMITS</td></tr><tr><td></td><td></td><td>PROPERTY LINE</td></tr><tr><td></td><td></td><td>LIMITS OF CUT</td></tr><tr><td></td><td></td><td>LIMITS OF FILL</td></tr><tr><td></td><td></td><td>SANITARY SEWER</td></tr><tr><td></td><td></td><td>SIGNAL OVERHEAD</td></tr><tr><td></td><td></td><td>STORM DRAIN</td></tr><tr><td></td><td></td><td>TELEPHONE DUCT</td></tr><tr><td></td><td></td><td>TELEPHONE OVERHEAD</td></tr><tr><td></td><td></td><td>TELEPHONE UNDERGROUND</td></tr><tr><td></td><td></td><td>WATER</td></tr></table>				EXIST.	PROP.	DESCRIPTION			BUILDING LINE			CABLE TELEVISION (OVERHEAD)			CABLE TELEVISION (UNDERGROUND)			CONDUIT			CONSTRUCTION CENTERLINE			EDGE OF SIDEWALK			EXISTING CROWN			FENCE BARBED WIRE			FENCE CHAIN LINK			FENCE WOOD			FIBER OPTIC AERIAL			FIBER OPTIC UNDERGROUND			INFILTRATION PIPE			GAS			HIGH PRESSURE GAS			POWER (OVERHEAD)			POWER (UNDERGROUND)			PROJECT LIMITS			PROPERTY LINE			LIMITS OF CUT			LIMITS OF FILL			SANITARY SEWER			SIGNAL OVERHEAD			STORM DRAIN			TELEPHONE DUCT			TELEPHONE OVERHEAD			TELEPHONE UNDERGROUND			WATER	CALL (2) BUSINESS DAYS BEFORE YOU DIG 811 or 1-800-424-5555				DUMP NO WASTE INTO STREAMS												
EXIST.	PROP.	DESCRIPTION																																																																																																													
		BUILDING LINE																																																																																																													
		CABLE TELEVISION (OVERHEAD)																																																																																																													
		CABLE TELEVISION (UNDERGROUND)																																																																																																													
		CONDUIT																																																																																																													
		CONSTRUCTION CENTERLINE																																																																																																													
		EDGE OF SIDEWALK																																																																																																													
		EXISTING CROWN																																																																																																													
		FENCE BARBED WIRE																																																																																																													
		FENCE CHAIN LINK																																																																																																													
		FENCE WOOD																																																																																																													
		FIBER OPTIC AERIAL																																																																																																													
		FIBER OPTIC UNDERGROUND																																																																																																													
		INFILTRATION PIPE																																																																																																													
		GAS																																																																																																													
		HIGH PRESSURE GAS																																																																																																													
		POWER (OVERHEAD)																																																																																																													
		POWER (UNDERGROUND)																																																																																																													
		PROJECT LIMITS																																																																																																													
		PROPERTY LINE																																																																																																													
		LIMITS OF CUT																																																																																																													
		LIMITS OF FILL																																																																																																													
		SANITARY SEWER																																																																																																													
		SIGNAL OVERHEAD																																																																																																													
		STORM DRAIN																																																																																																													
		TELEPHONE DUCT																																																																																																													
		TELEPHONE OVERHEAD																																																																																																													
		TELEPHONE UNDERGROUND																																																																																																													
		WATER																																																																																																													
CONSTRUCTION SYMBOLS <table><tr><td></td><td>CONSTRUCTION NOTES</td></tr><tr><td></td><td>CHANNELIZATION & ILLUMINATION NOTES</td></tr><tr><td></td><td>DEMOLITION SITE PREPARATION NOTES</td></tr><tr><td></td><td>EROSION & SEDIMENT CONTROL NOTES</td></tr><tr><td></td><td>SECTION NOTES</td></tr><tr><td></td><td>STORM DRAINAGE NOTES</td></tr><tr><td></td><td>HMA ROADWAY OR PATCH</td></tr><tr><td></td><td>PROPOSED CEMENT CONCRETE CURB, GUTTER, SIDEWALK, AND DRIVEWAYS</td></tr><tr><td></td><td>HMA FOR APPROACH</td></tr><tr><td></td><td>PLAINING EXISTING PAVEMENT</td></tr><tr><td></td><td>PULVERIZE EXISTING PAVEMENT</td></tr></table>					CONSTRUCTION NOTES		CHANNELIZATION & ILLUMINATION NOTES		DEMOLITION SITE PREPARATION NOTES		EROSION & SEDIMENT CONTROL NOTES		SECTION NOTES		STORM DRAINAGE NOTES		HMA ROADWAY OR PATCH		PROPOSED CEMENT CONCRETE CURB, GUTTER, SIDEWALK, AND DRIVEWAYS		HMA FOR APPROACH		PLAINING EXISTING PAVEMENT		PULVERIZE EXISTING PAVEMENT	SURVEY SYMBOLS <table><tr><th>EXIST.</th><th>PROP.</th><th>DESCRIPTION</th></tr><tr><td></td><td></td><td>MONUMENT (IN CASE)</td></tr><tr><td></td><td></td><td>SURVEY IRON PIPE</td></tr><tr><td></td><td></td><td>SURVEY CONTROL NAIL</td></tr><tr><td></td><td></td><td>SURVEY CONTROL "X" SCRIBE</td></tr><tr><td></td><td></td><td>BENCH MARK</td></tr></table> THE EXISTING TOPOGRAPHIC AND PHYSICAL FEATURES SHOWN ON THESE PLANS ARE BASED ON A COMBINATION OF: FIELD SURVEY AND AS-BUILTS FROM PIERCE COUNTY FIELD SURVEY DATA BY THE SURVEYOR OF RECORD FRANCHISE UTILITY COMPANY RECORDS FIELD RECONNAISSANCE BY CITY OF LAKEWOOD PUBLIC WORKS ENGINEERING DEPARTMENT THIS WAS THE INFORMATION AVAILABLE AT THE TIME OF PLAN PREPARATION. ACTUAL CONDITIONS MAY BE DIFFERENT. THE CONTRACTOR MAY ENCOUNTER VARIATIONS BETWEEN ACTUAL CONDITIONS AND THOSE SHOWN. THESE VARIATIONS WILL NOT BE THE BASIS FOR A CLAIM OR EXTRA COMPENSATION. THE LOCATIONS OF EXISTING UNDERGROUND UTILITIES ARE SHOWN IN AN APPROXIMATE WAY ONLY AND HAVE NOT BEEN INDEPENDENTLY VERIFIED BY THE CITY OF LAKEWOOD. THE CONTRACTOR SHALL DETERMINE THE EXACT LOCATION OF ALL EXISTING UTILITIES BEFORE COMMENCING WORK, AND AGREES TO BE FULLY RESPONSIBLE FOR ANY AND ALL DAMAGES WHICH MIGHT BE ENCOUNTER BY THE CONTRACTOR'S FAILURE TO EXACTLY LOCATE AND PRESERVE ANY AND ALL UNDERGROUND UTILITIES.				EXIST.	PROP.	DESCRIPTION			MONUMENT (IN CASE)			SURVEY IRON PIPE			SURVEY CONTROL NAIL			SURVEY CONTROL "X" SCRIBE			BENCH MARK																																																																
	CONSTRUCTION NOTES																																																																																																														
	CHANNELIZATION & ILLUMINATION NOTES																																																																																																														
	DEMOLITION SITE PREPARATION NOTES																																																																																																														
	EROSION & SEDIMENT CONTROL NOTES																																																																																																														
	SECTION NOTES																																																																																																														
	STORM DRAINAGE NOTES																																																																																																														
	HMA ROADWAY OR PATCH																																																																																																														
	PROPOSED CEMENT CONCRETE CURB, GUTTER, SIDEWALK, AND DRIVEWAYS																																																																																																														
	HMA FOR APPROACH																																																																																																														
	PLAINING EXISTING PAVEMENT																																																																																																														
	PULVERIZE EXISTING PAVEMENT																																																																																																														
EXIST.	PROP.	DESCRIPTION																																																																																																													
		MONUMENT (IN CASE)																																																																																																													
		SURVEY IRON PIPE																																																																																																													
		SURVEY CONTROL NAIL																																																																																																													
		SURVEY CONTROL "X" SCRIBE																																																																																																													
		BENCH MARK																																																																																																													
No.	Release/Revision	Re. Date	Re. By	Designed By: T. POKSWINSKI	CITY OF LAKEWOOD WA 1996 THOMAS S. POKSWINSKI STATE OF WASHINGTON REGISTERED PROFESSIONAL ENGINEER 6/13/23	Project Name: UNION AVENUE SW IMPROVEMENTS	Job No. 302.0096																																																																																																								
				Entered By: A. DOBROVIDOVA		Drawing Name: LEGENDS, ABBREVIATIONS, NOTES, AND SYMBOLS	Drawing No. LA																																																																																																								
				Checked By: C. T. HILL																																																																																																											
				Approved By: P. BUCICH																																																																																																											
				Project Start Date: XX/XX/23			Sheet 2																																																																																																								
				Drawing Scale: AS SHOWN			of 20																																																																																																								
				Electronic File Name: 302.0096																																																																																																											

SECTION 21,22; TOWNSHIP 19N; RANGE 2E

THE CONSTRUCTION ALIGNMENTS SHOWN BELOW ARE THE BASIS FOR THE PROPOSED CROWNLINE. IN NO CIRCUMSTANCE DOES THE CONSTRUCTION ALIGNMENT PARALLEL THE RIGHT-OF-WAY CENTERLINE.

ALIGNMENT CONTROL			
NAME	STATION	NORTHING	EASTING
UNION	200+00.00	657955.06	1128136.97

ALIGNMENT TANGENT DATA 210+00 LINE		
STATION	BEARING	DISTANCE
200+00.00	N50°43'19"E	1125.24'
211+25.24	N50°43'23"E	2250.23'
233+75.47	N50°44'25"E	808.31'




SURVEY CONTROL
BASIS OF BEARING


NAD 1983
WASHINGTON STATE PLANE SOUTH PROJECTION, BASED ON GPS
OBSERVATIONS USING WSRN AND GEOID 2012A. UNITS OF MEASUREMENT
ARE US SURVEY FEET.

VERTICAL DATUM

NAVD 1988 VERTICAL DATUM ON ORTHOMETRICALLY CORRECTED GPS
OBSERVATIONS USING WSRN AND GEOID 2012A.




SURVEY CONTROL				
PNT NO.	NORTHING	EASTING	ELEV.	DESC.
1	658784.62	1129182.91	N/A	MON IN CASE
2	659195.20	1128847.65	275.33	BRASS CAP

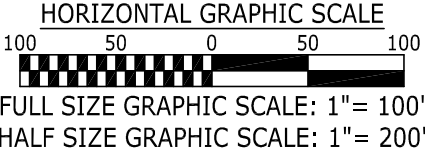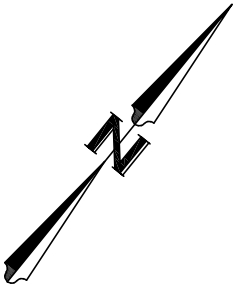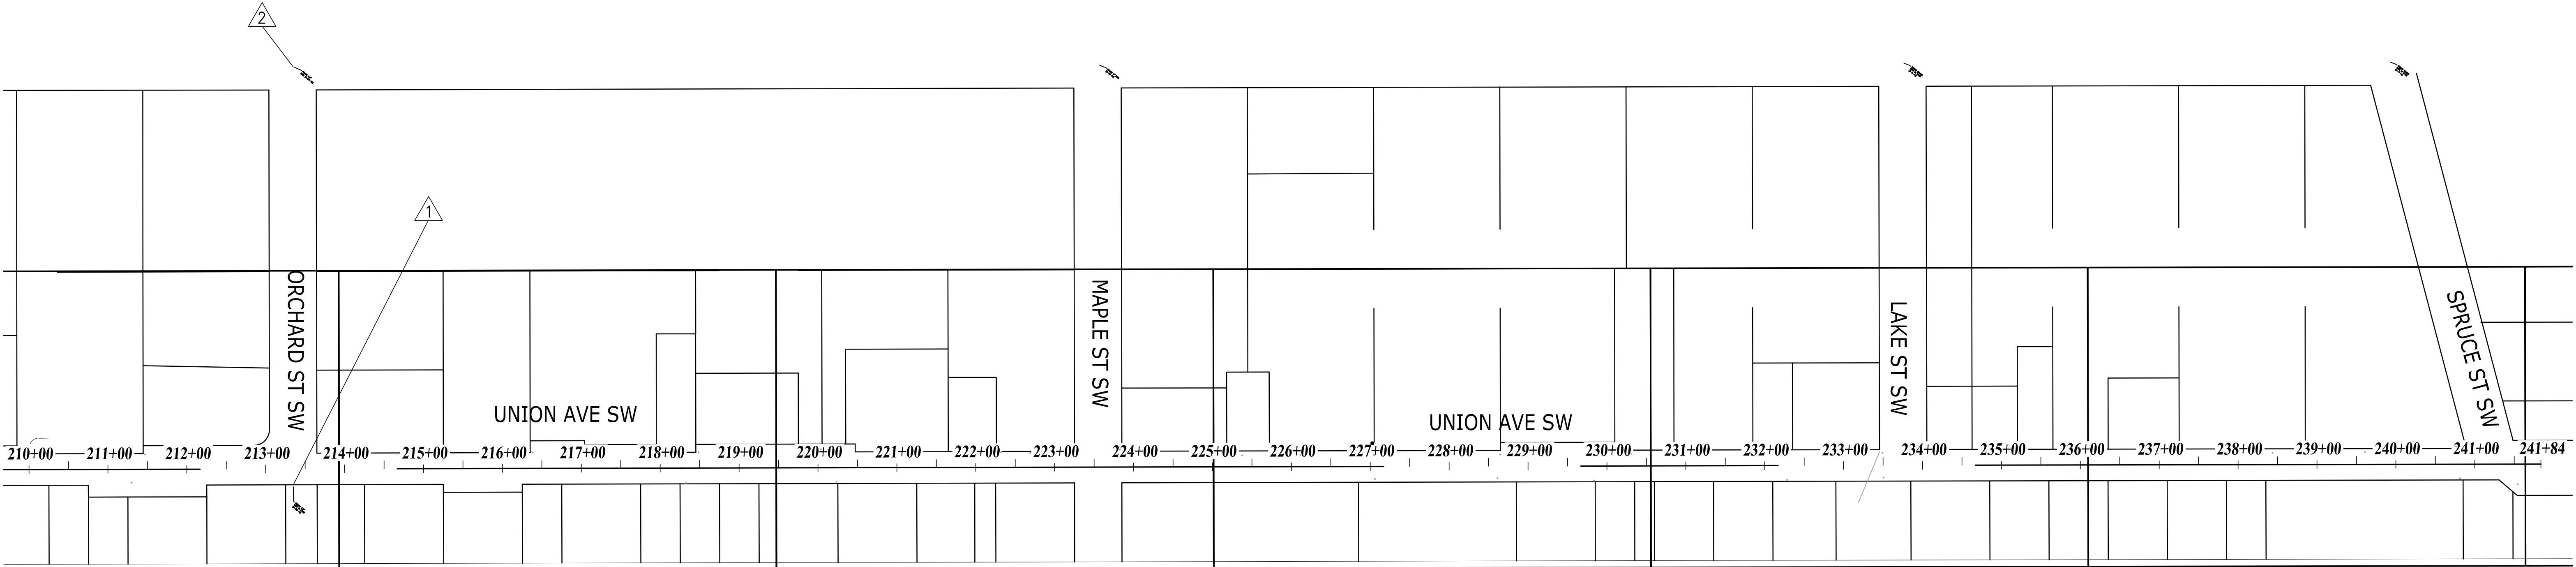

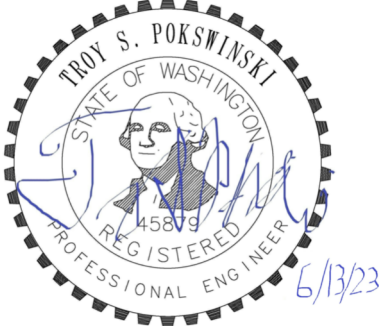
No.	Release/Revision	Re. Date	Re. By	Designed By: T. POKSWINSKI		Project Name: UNION AVENUE SW IMPROVEMENTS	Job No. 302.0096
				Entered By: A. DOBROVIDOVA		Drawing Name:	Drawing No. AL
				Checked By: C. T. HILL		ALIGNMENT PLAN	Sheet 3 of 20
				Approved By: P. BUCICH			
				Project Start Date: XX/XX/23			
				Drawing Scale: AS SHOWN			
				Electronic File Name: 302.0096			

SECTION NOTES:

- ① REVERSE EDGE GRIND (2" ON ϕ , 0 7'RT)
- ② REMOVE EXIST HMA/WEDGE CURB 7'RT TO 12'RT
- ③ 2" CRUSHED SURFACING TOP COURSE
- ④ 4" HMA CLASS $\frac{1}{2}$ " PG 58H –22 BASE LIFT
- ⑤ 2" HMA CLASS $\frac{1}{2}$ " PG 58H –22 OVERLAY – 9.5'WIDE
- ⑥ CEMENT CONCRETE CURB AND GUTTER
- ⑦ CEMENT CONCRETE SIDEWALK
- ⑧ PROPERTY RESTORATION; MATCH EXISTING
- ⑨ COMPACTED SUBGRADE

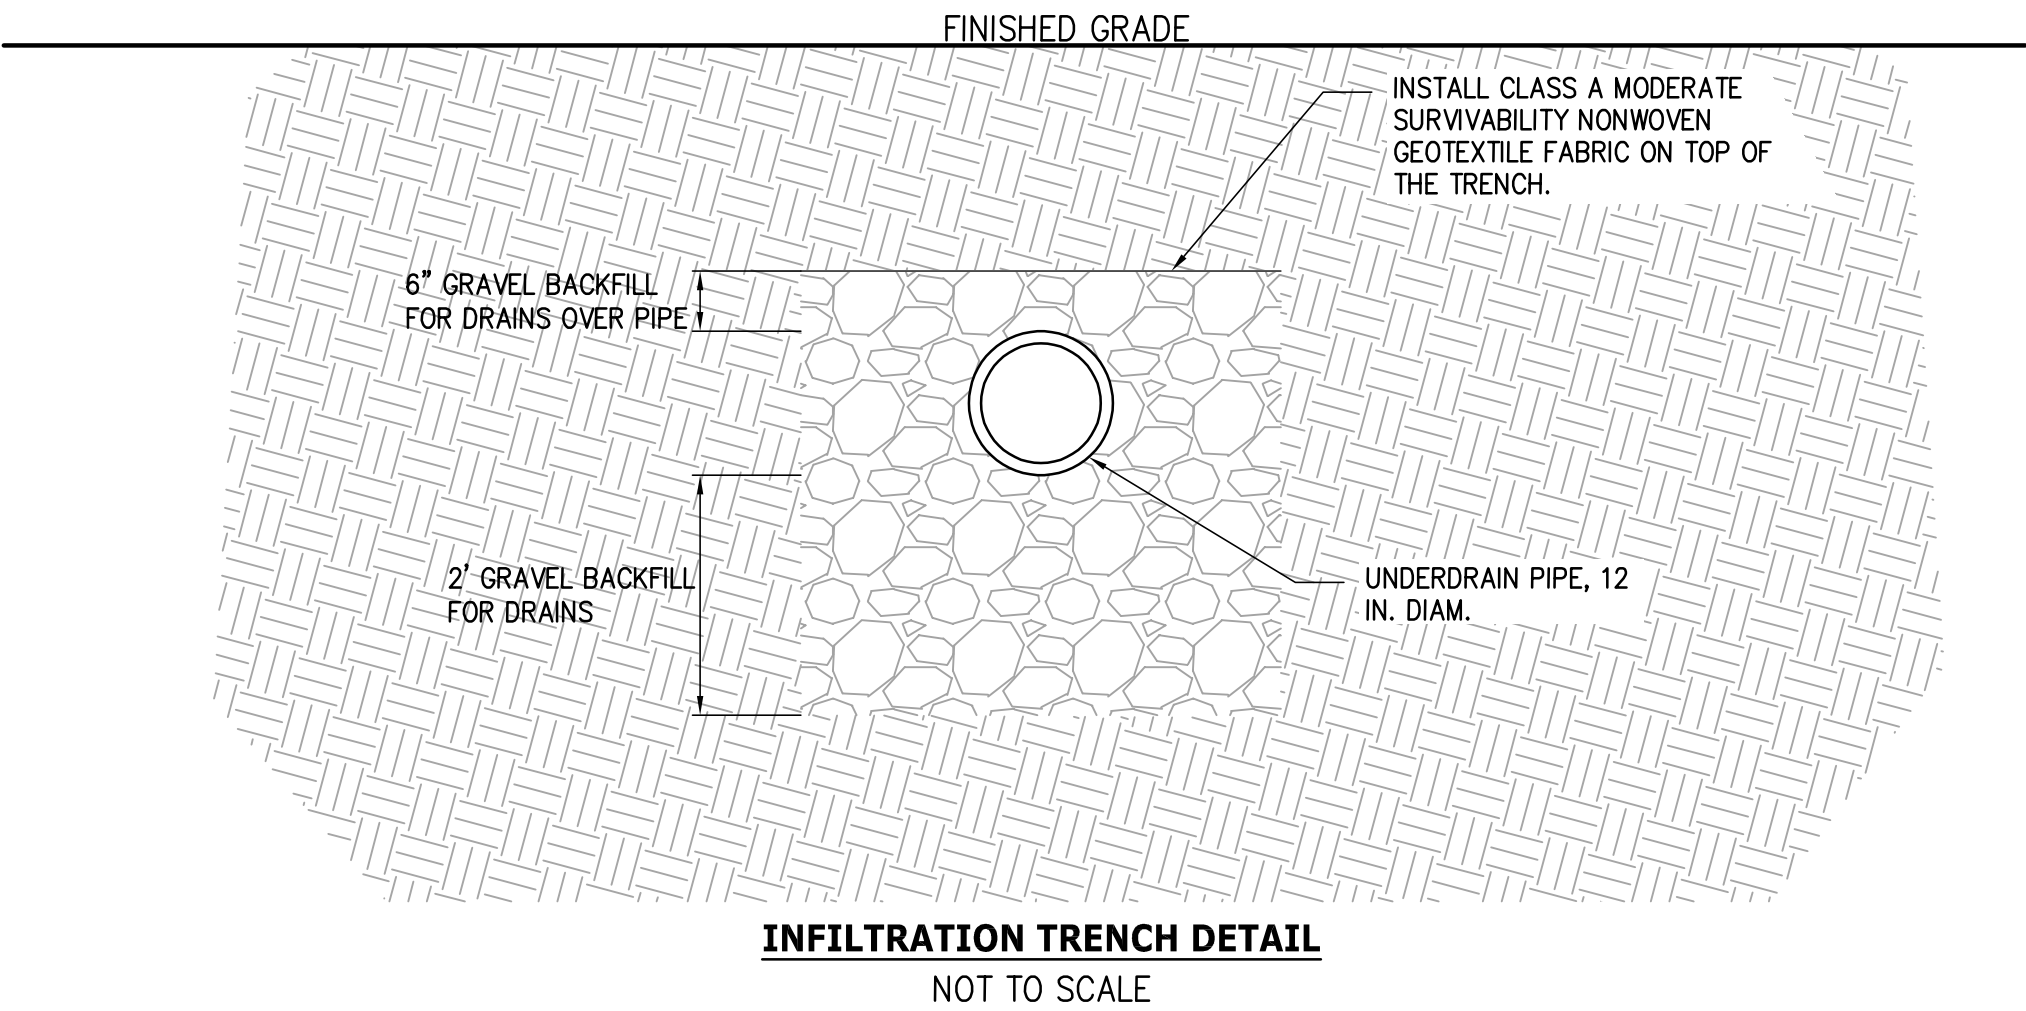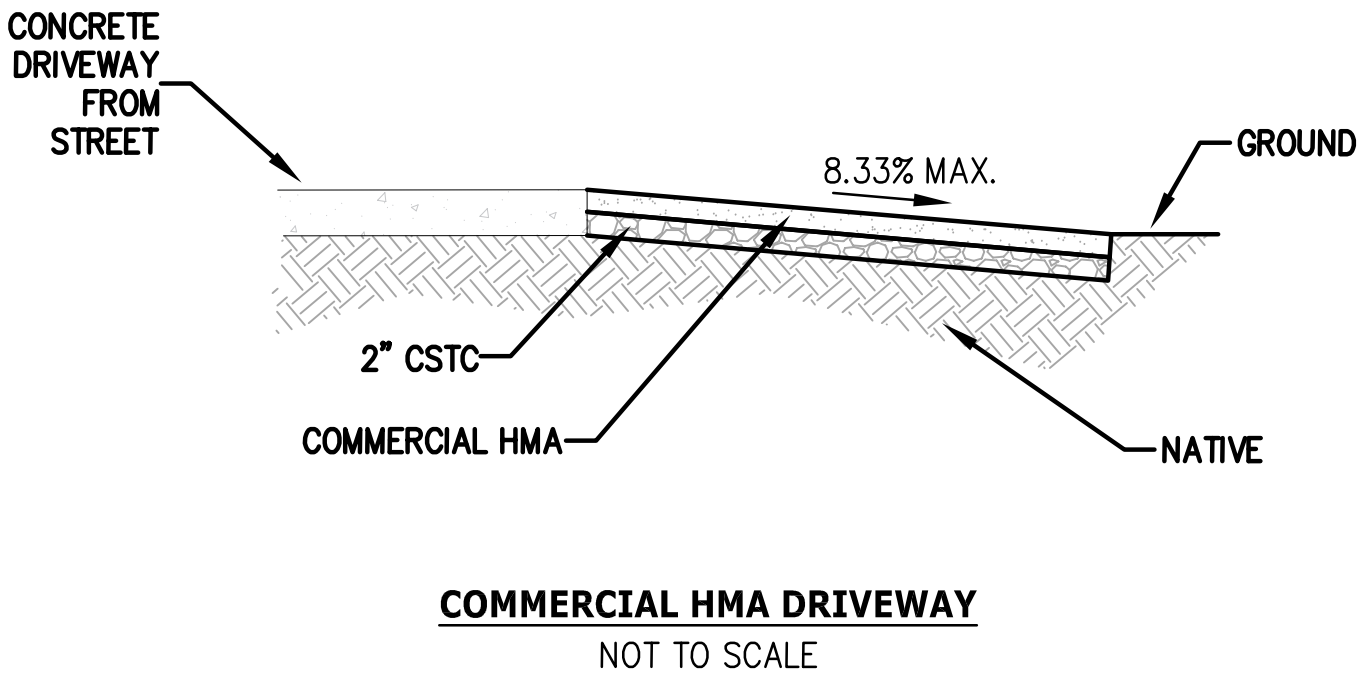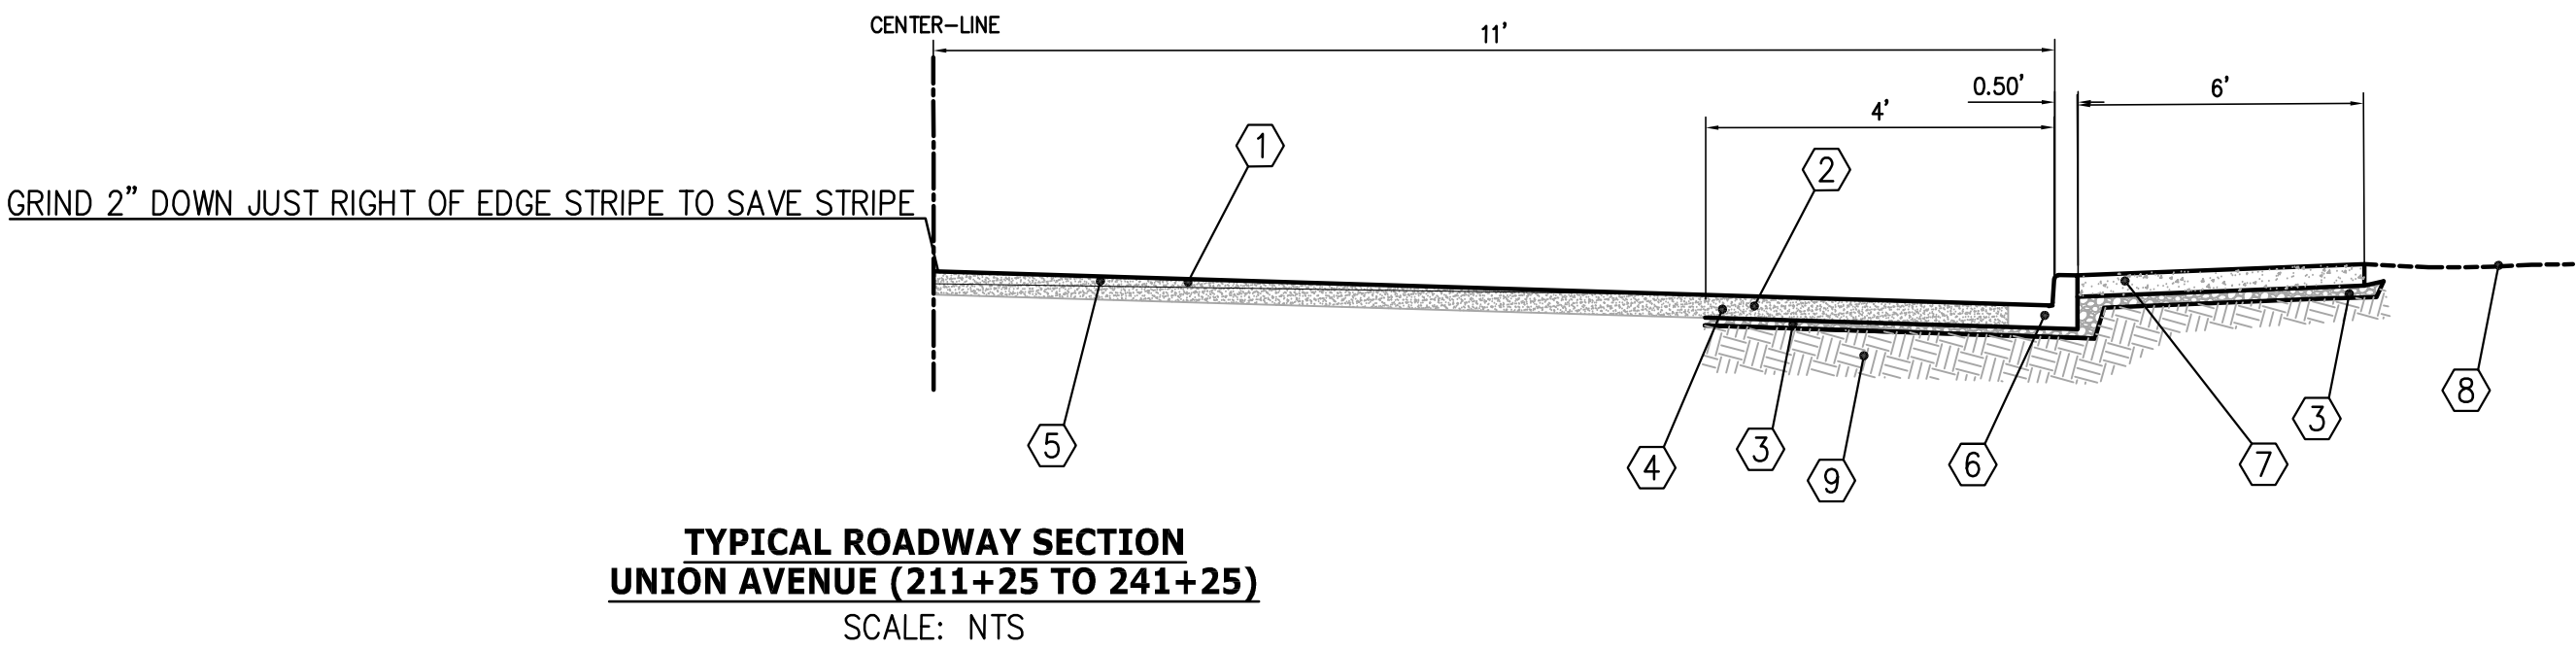

No.	Release/Revision	Re. Date	Re. By	Designed By: T. POKSWINSKI	CITY OF LAKEWOOD, WA 1996 THOMAS S. POKSWINSKI STATE OF WASHINGTON REGISTERED PROFESSIONAL ENGINEER 6/13/23	Project Name: UNION AVENUE SW IMPROVEMENTS	Job No. 302.0096
				Entered By: A. DOBROVIDOVA		Drawing Name: ROADWAY SECTIONS	Drawing No. RS
				Checked By: C. T. HILL			
				Approved By: P. BUCICH			
				Project Start Date: XX/XX/23			Sheet 4
				Drawing Scale: AS SHOWN			of 20
				Electronic File Name: 302.0096			

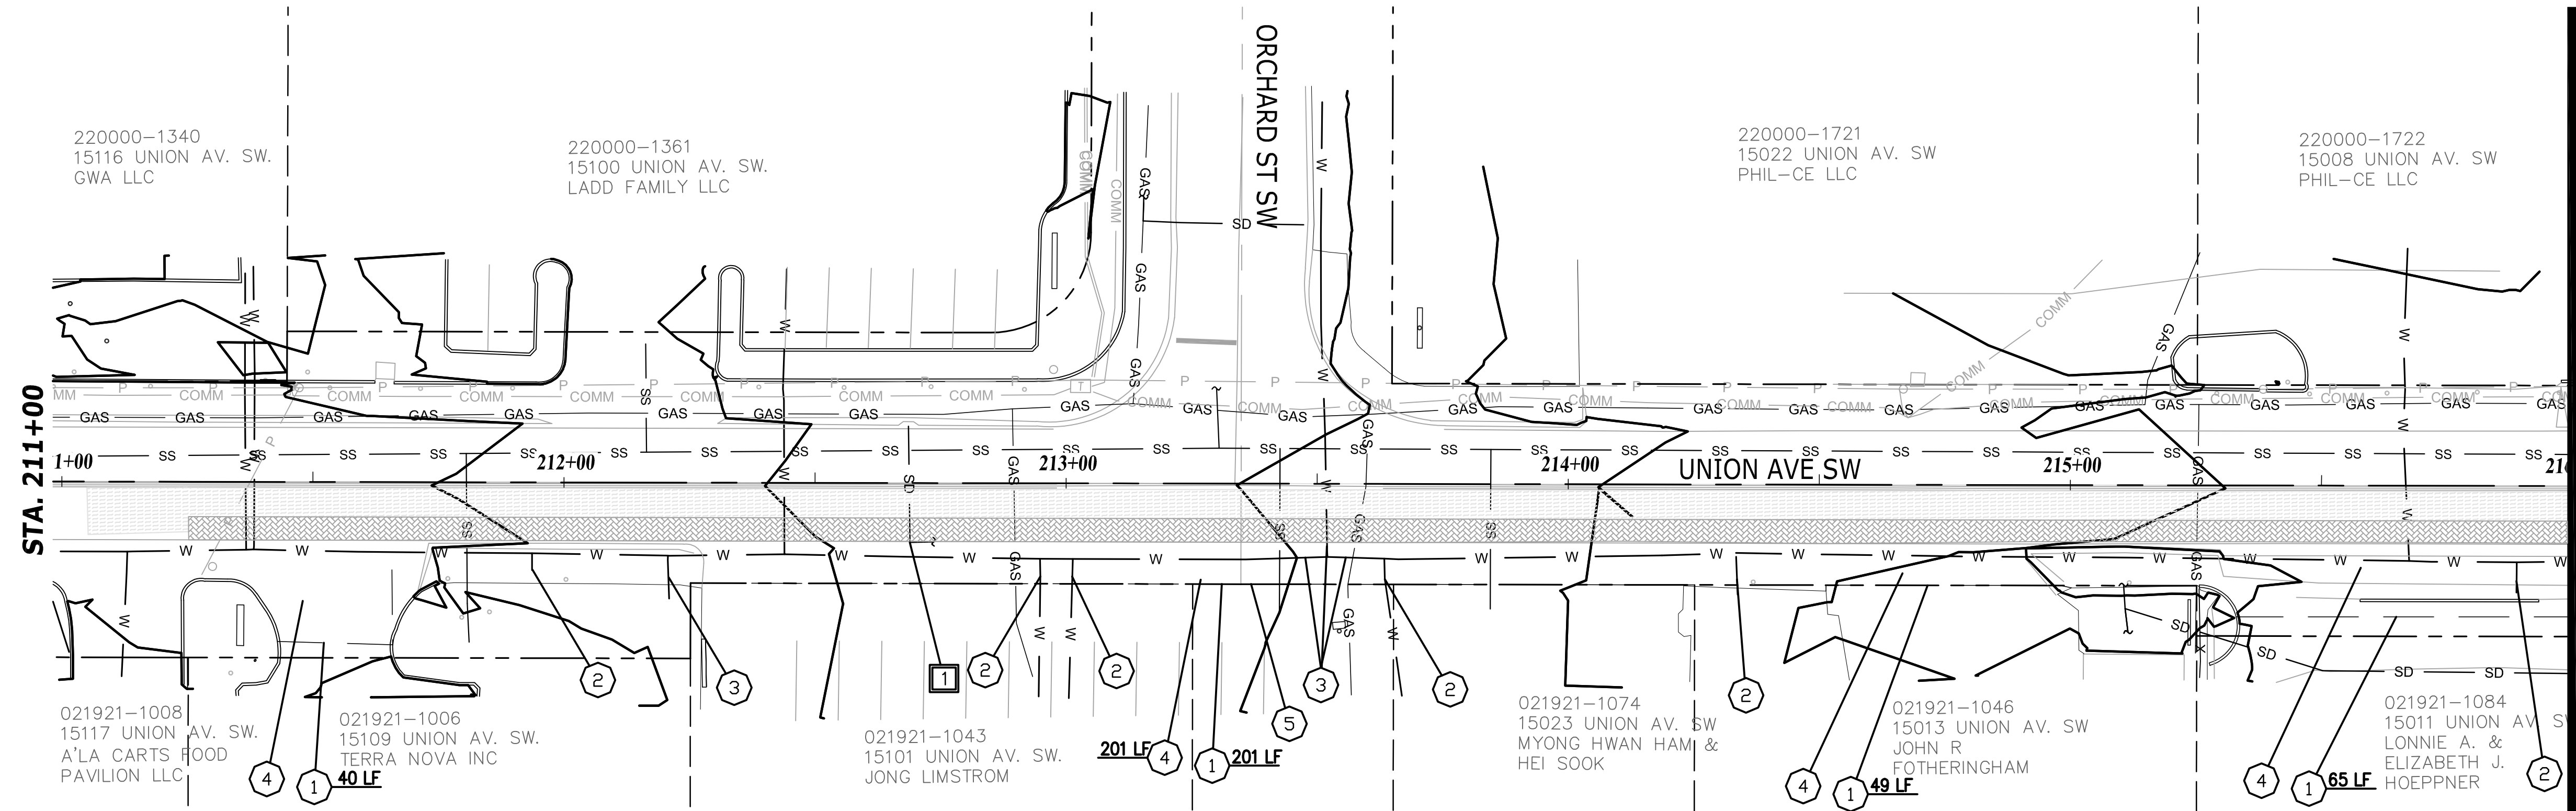

EROSION AND SEDIMENT CONTROL NOTES:



1. INSTALL INLET PROTECTION PER CITY OF LAKEWOOD STD PLAN SW-15

DEMOLITION LEGEND

- REVERSE EDGE GRIND. SET JUST RIGHT OF EXISTING STRIPE TO PRESERVE THE EXISTING MARKING. GRIND 2" DEPTH ON THAT LINE. DAYLIGHT TO 0" GRIND 7"RT.
- REMOVE 4" DEPTH HMA 7"RT THROUGH WEDGE CURB 11-12"RT


SITE PREPARATION NOTES

1. SAWCUT LINE
2. LAKEWOOD WATER DISTRICT TO ADJUST EXISTING WATER METER BOX. CONTRACTOR TO COORD. WITH THE DISTRICT TO SET BOX AT GRADE.
3. LOWER EXISTING SEWER MANHOLE, WATER VALVE, OR GAS VALVE PRIOR TO PAVING
4. REMOVE ASPHALT OR CONCRETE DRIVEWAY APRON
5. PROTECT EXISTING MONUMENT.

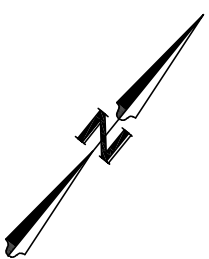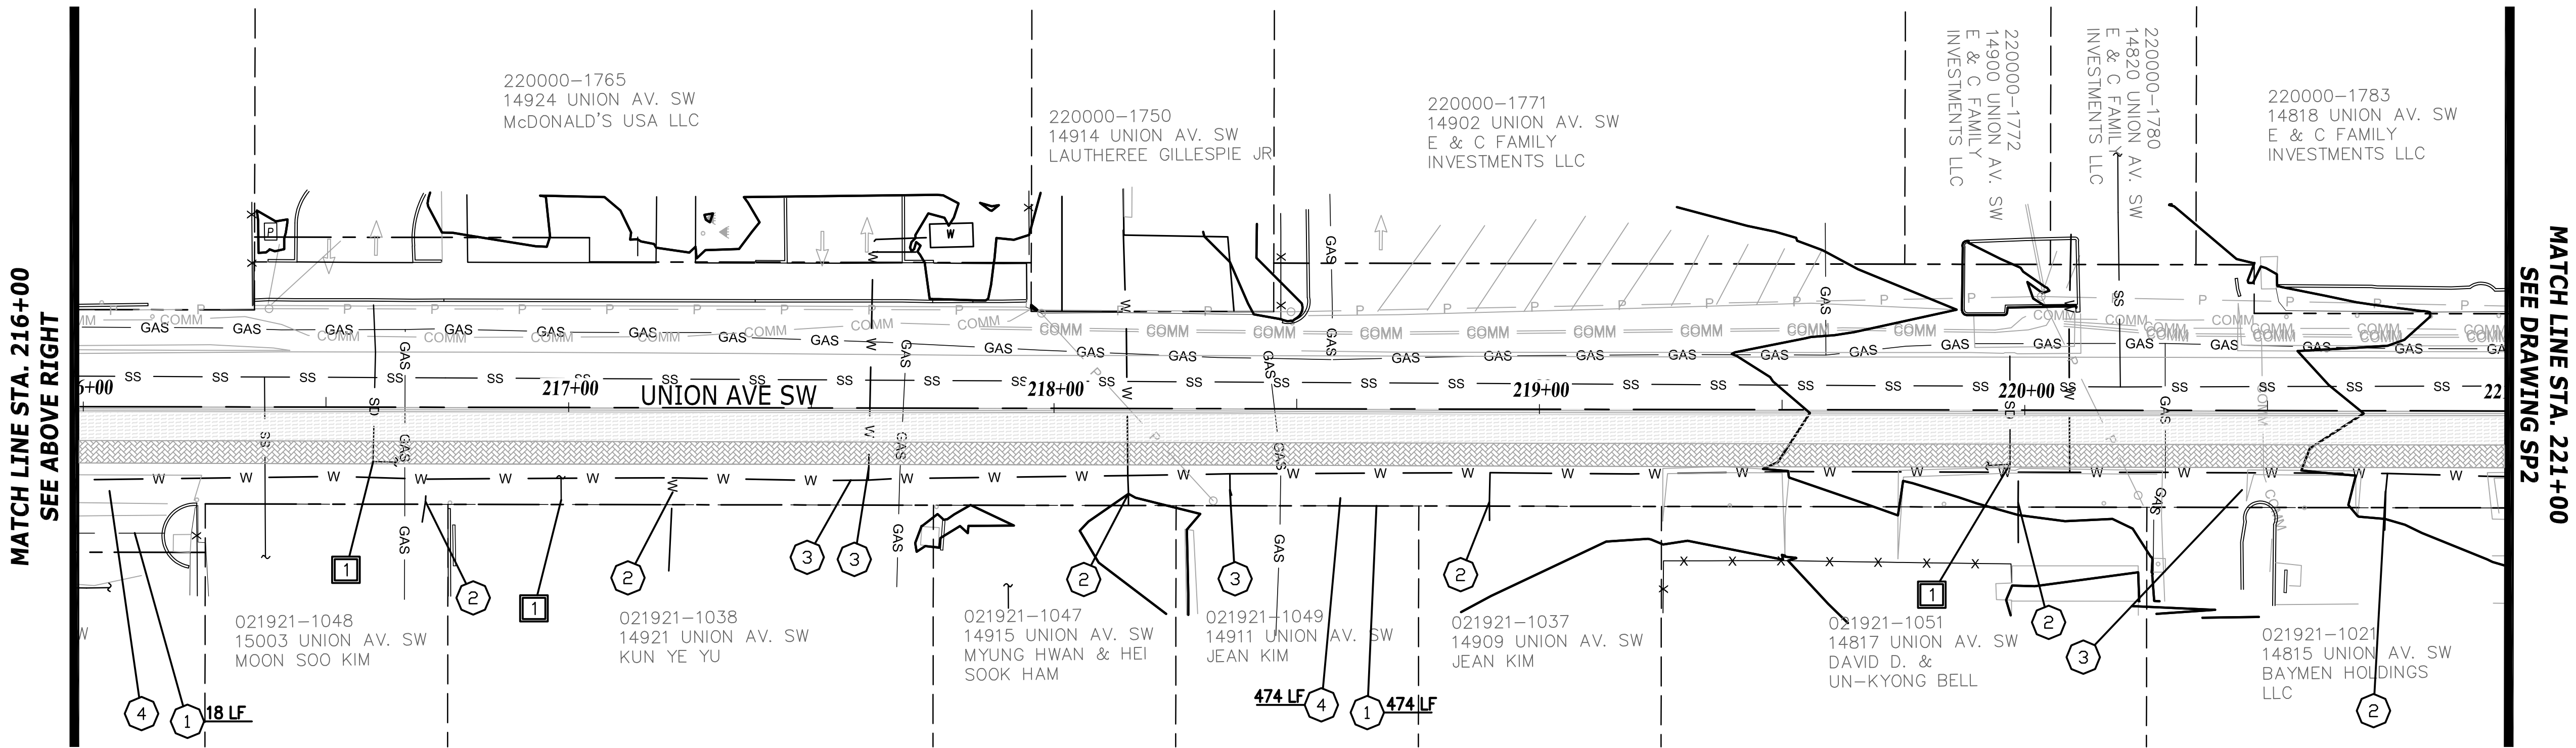




HORIZONTAL GRAPHIC SCALE
20 10 0 10 20
FULL SIZE GRAPHIC SCALE: 1"= 20'
HALF SIZE GRAPHIC SCALE: 1"= 40'

No.	Release/Revision	Re. Date	Re. By	Designed By:	Project Name:	Job No.
△				T. POKSWINSKI	UNION AVENUE SW IMPROVEMENTS	302.0096
△				Entered By: A. DOBROVIDOVA		Drawing No. SP-1
△				Checked By: C. T. HILL		Sheet 5 of 20
△				Approved By: P. BUCICH		
△				Project Start Date: XX/XX/23 Drawing Scale: AS SHOWN	SITE PREPARATION STA. 211+00 TO STA. 221+00	
△				Electronic File Name: 302.0096		

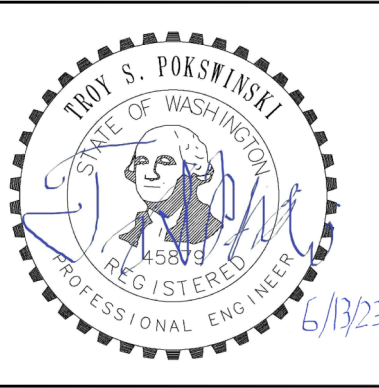

No.	Release/Revision	Re. Date	Re. By	Designed By: T. POKSWINSKI			Project Name:	Job No.
				Entered By: A. DOBROVIDOVA			UNION AVENUE SW IMPROVEMENTS	302.0096
				Checked By: C. T. HILL				Drawing No.
				Approved By: P. BUCICH				SP-2
				Project Start Date: XX/XX/23			Drawing Name:	SITE PREPARATION STA. 221+00 TO STA. 231+00
				Drawing Scale: AS SHOWN				Sheet 6 of 20
				Electronic File Name: 302.0096				

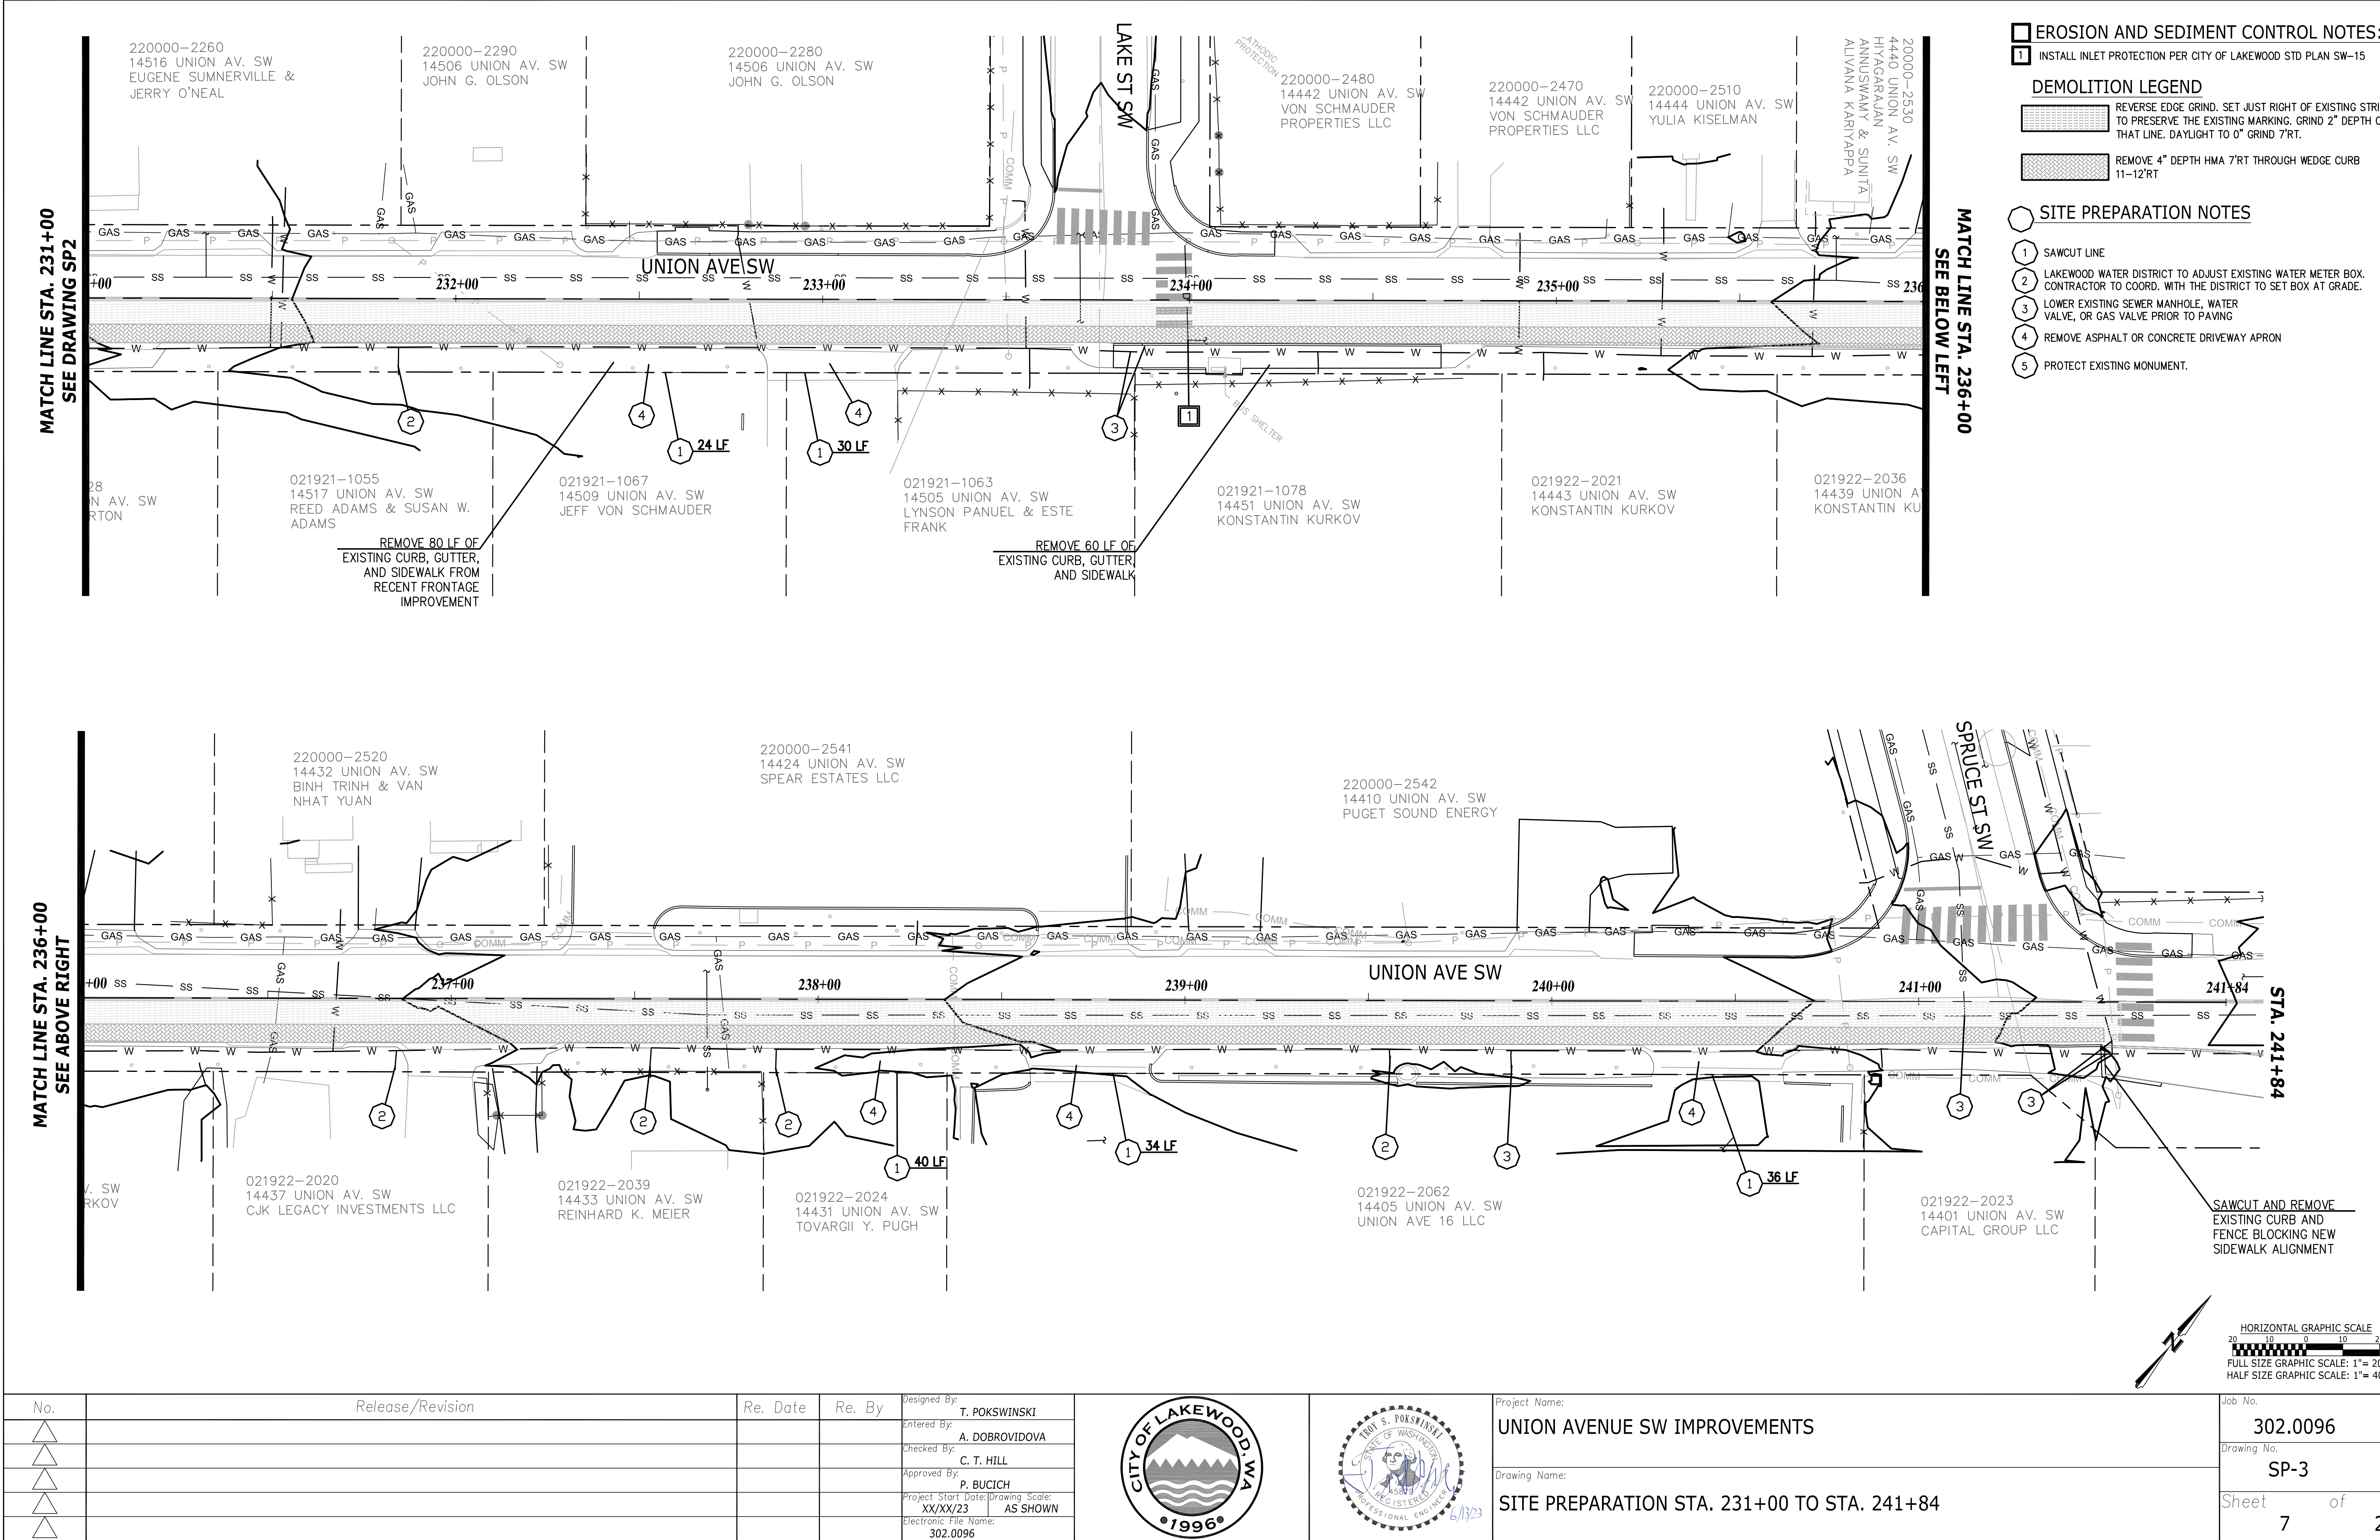


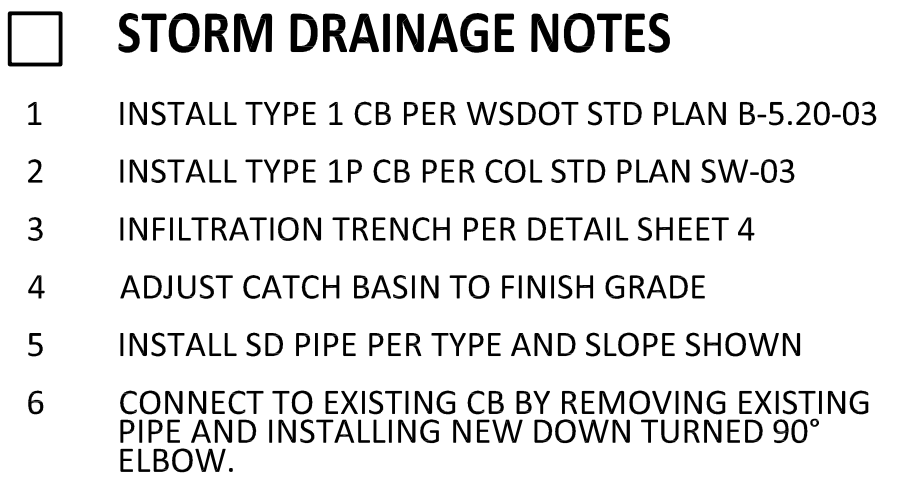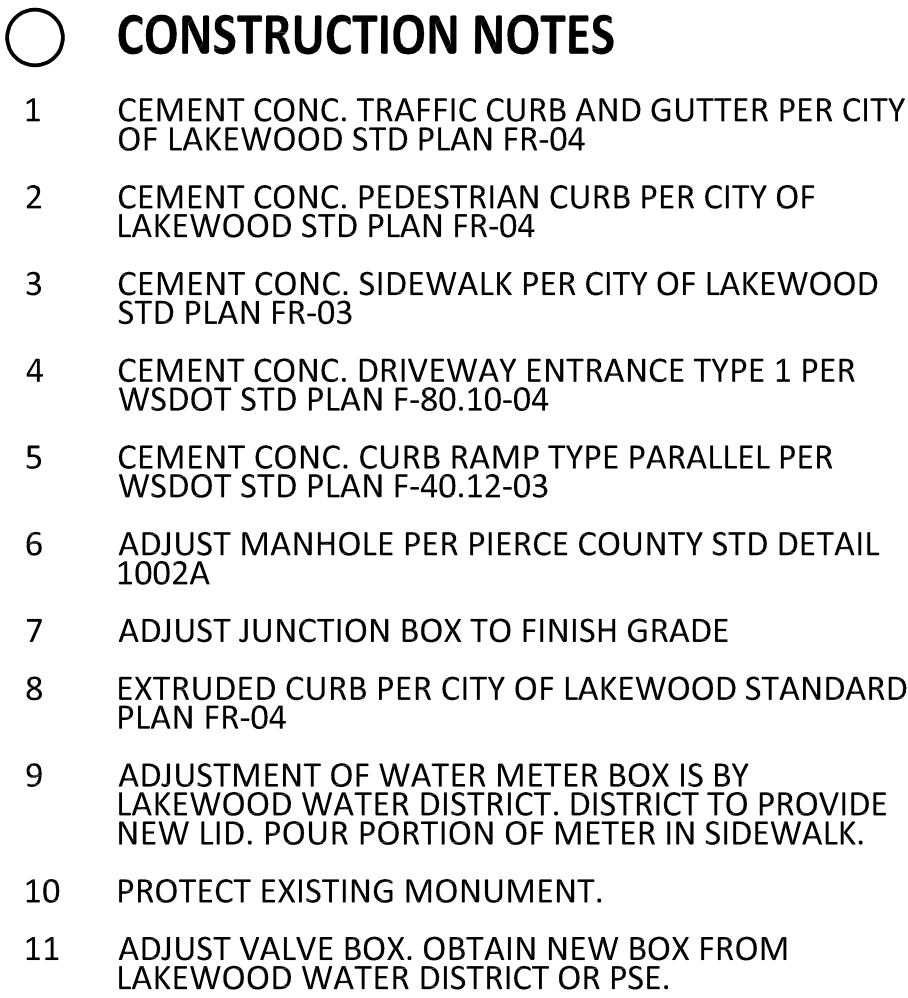


1 ALIGNMENT AND STATIONING PER SURVEYED
MONUMENTS, SEE SHEET 3

2 CURB ELEVATIONS ARE TO TOP BACK OF CURB

DRIVEWAY SCHEDULE				
ALIGNMENT	STATION	OFFSET	WIDTH	SAWCUT (BACK OF WALK)
UNION	211+54	11.5'RT	24'	14.0'
UNION	212+41	11.5'RT	24'	2.5'
UNION	213+42	11.5'RT	24'	2.5'
UNION	213+87	11.5'RT	30'	2.5'
UNION	214+65	11.5'RT	24'	2.5'
UNION	215+45	11.5'RT	24'	8.5'
DRIVEWAY CENTERLINE STATION AND BACK OF CURB OFFSET				

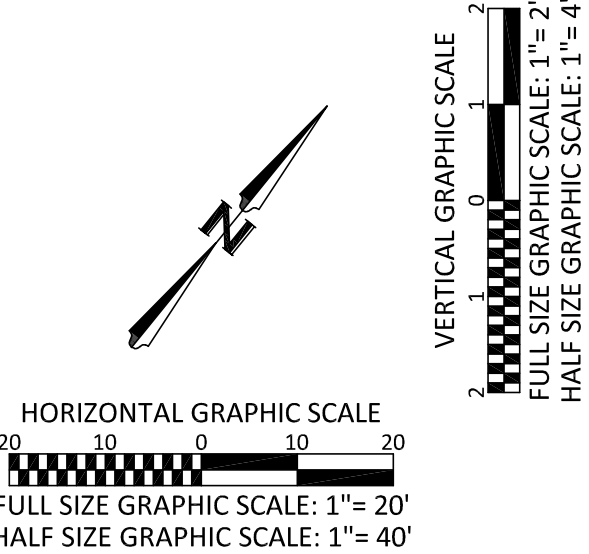[illegible]


No.	Release/Revision	Re. Date	Re. By	Designed By: T. POKSWINSKI			Project Name:	UNION AVENUE SW IMPROVEMENTS	Job No.	302.0096
				Entered By: A. DOBROVIDOVA			Drawing No.		PP1	
				Checked By: C. T. HILL			Drawing Name: PLAN AND PROFILE STA. 211+00 TO STA. 216+00			
				Approved By: P. BUCICH						
				Project Start Date: XX/XX/23				Drawing Scale: AS SHOWN		
				Electronic File Name: 302.0096						
								Sheet 8 of 20		

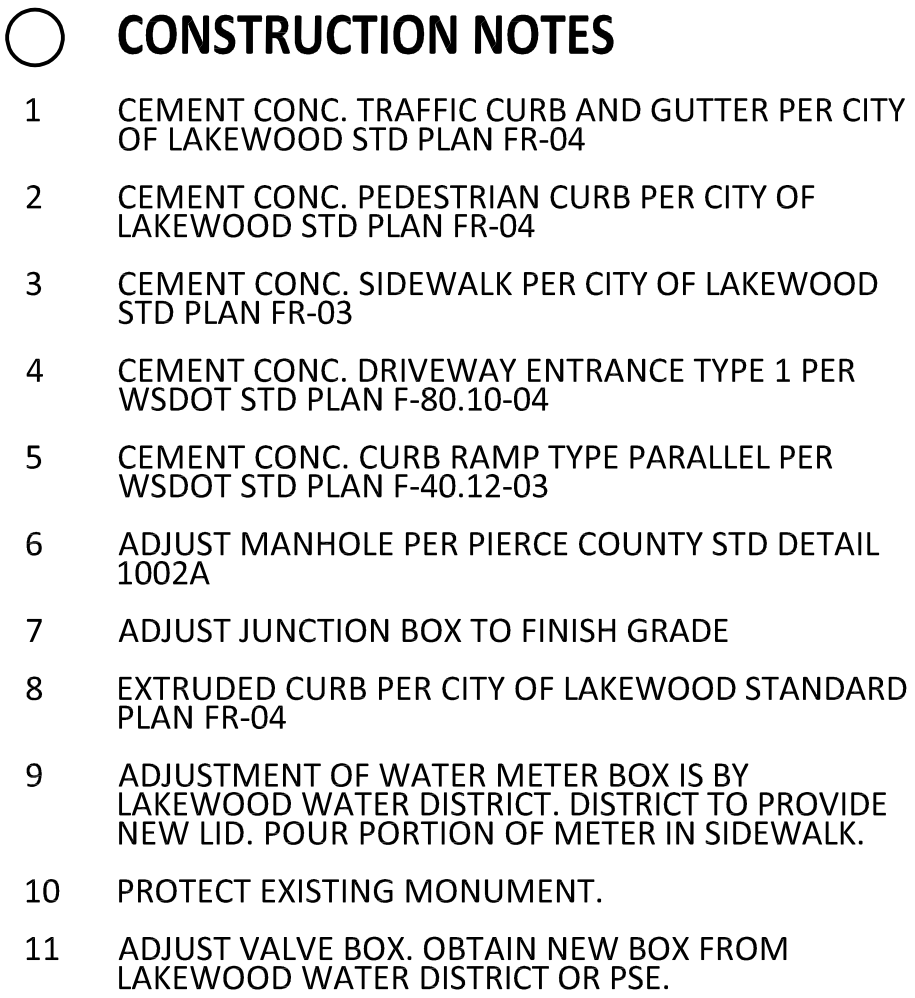

- 1 INSTALL TYPE 1 CB PER WSDOT STD PLAN B-5-20-03
- 2 INSTALL TYPE 1P CB PER COL STD PLAN SW-03
- 3 INFILTRATION TRENCH PER DETAIL SHEET 4
- 4 ADJUST CATCH BASIN TO FINISH GRADE
- 5 INSTALL SD PIPE PER TYPE AND SLOPE SHOWN
- 6 CONNECT TO EXISTING CB BY REMOVING EXISTING
PIPE AND INSTALLING NEW DOWN TURNED 90°
ELBOW.


1 ALIGNMENT AND STATIONING PER SURVEYED
MONUMENTS, SEE SHEET 3

2 CURB ELEVATIONS ARE TO TOP BACK OF CURB

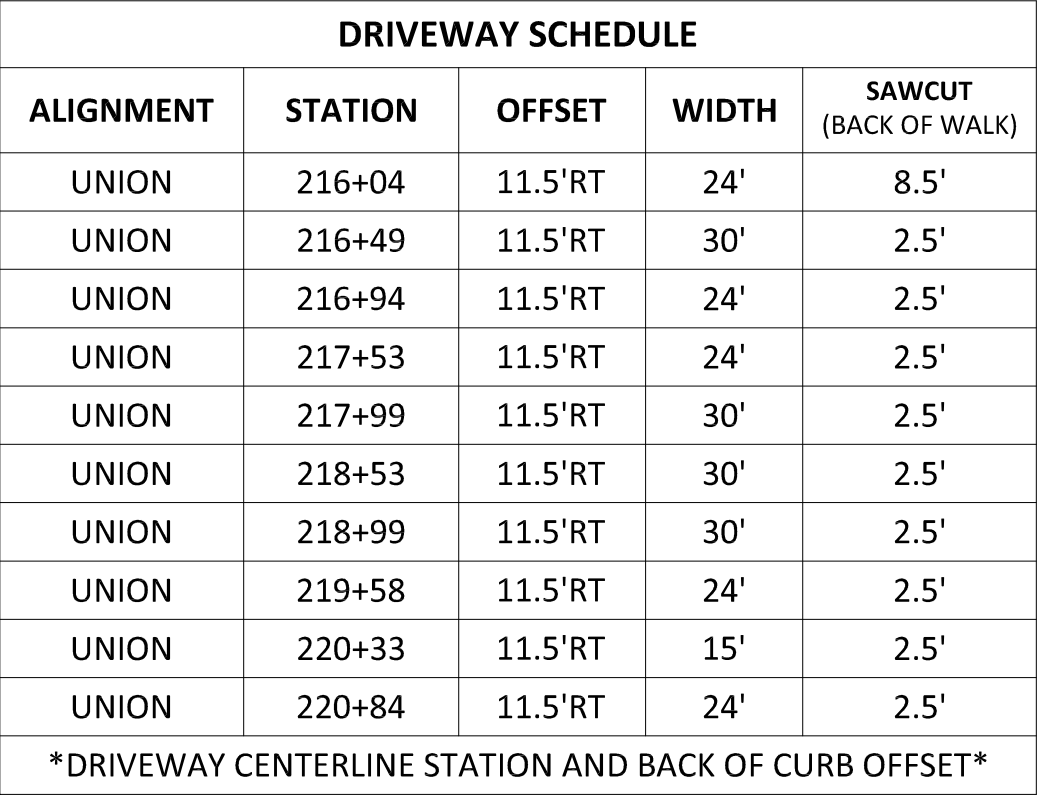

No.	Release/Revision	Re. Date	Re. By	Designed By: T. POKSWINSKI			Project Name:	Job No.	
				Entered By: A. DOBROVIDOVA			UNION AVENUE SW IMPROVEMENTS	302.0096	
				Checked By: C. T. HILL				Drawing No.	
				Approved By: P. BUCICH			Drawing Name:	PP2	
				Project Start Date: XX/XX/23			Drawing Scale: AS SHOWN	PLAN AND PROFILE STA. 216+00 TO STA. 221+00	Sheet 9 of 20
				Electronic File Name: 302.0096					

MATCH LINE STA. 221+00
SEE DRAWING PP2

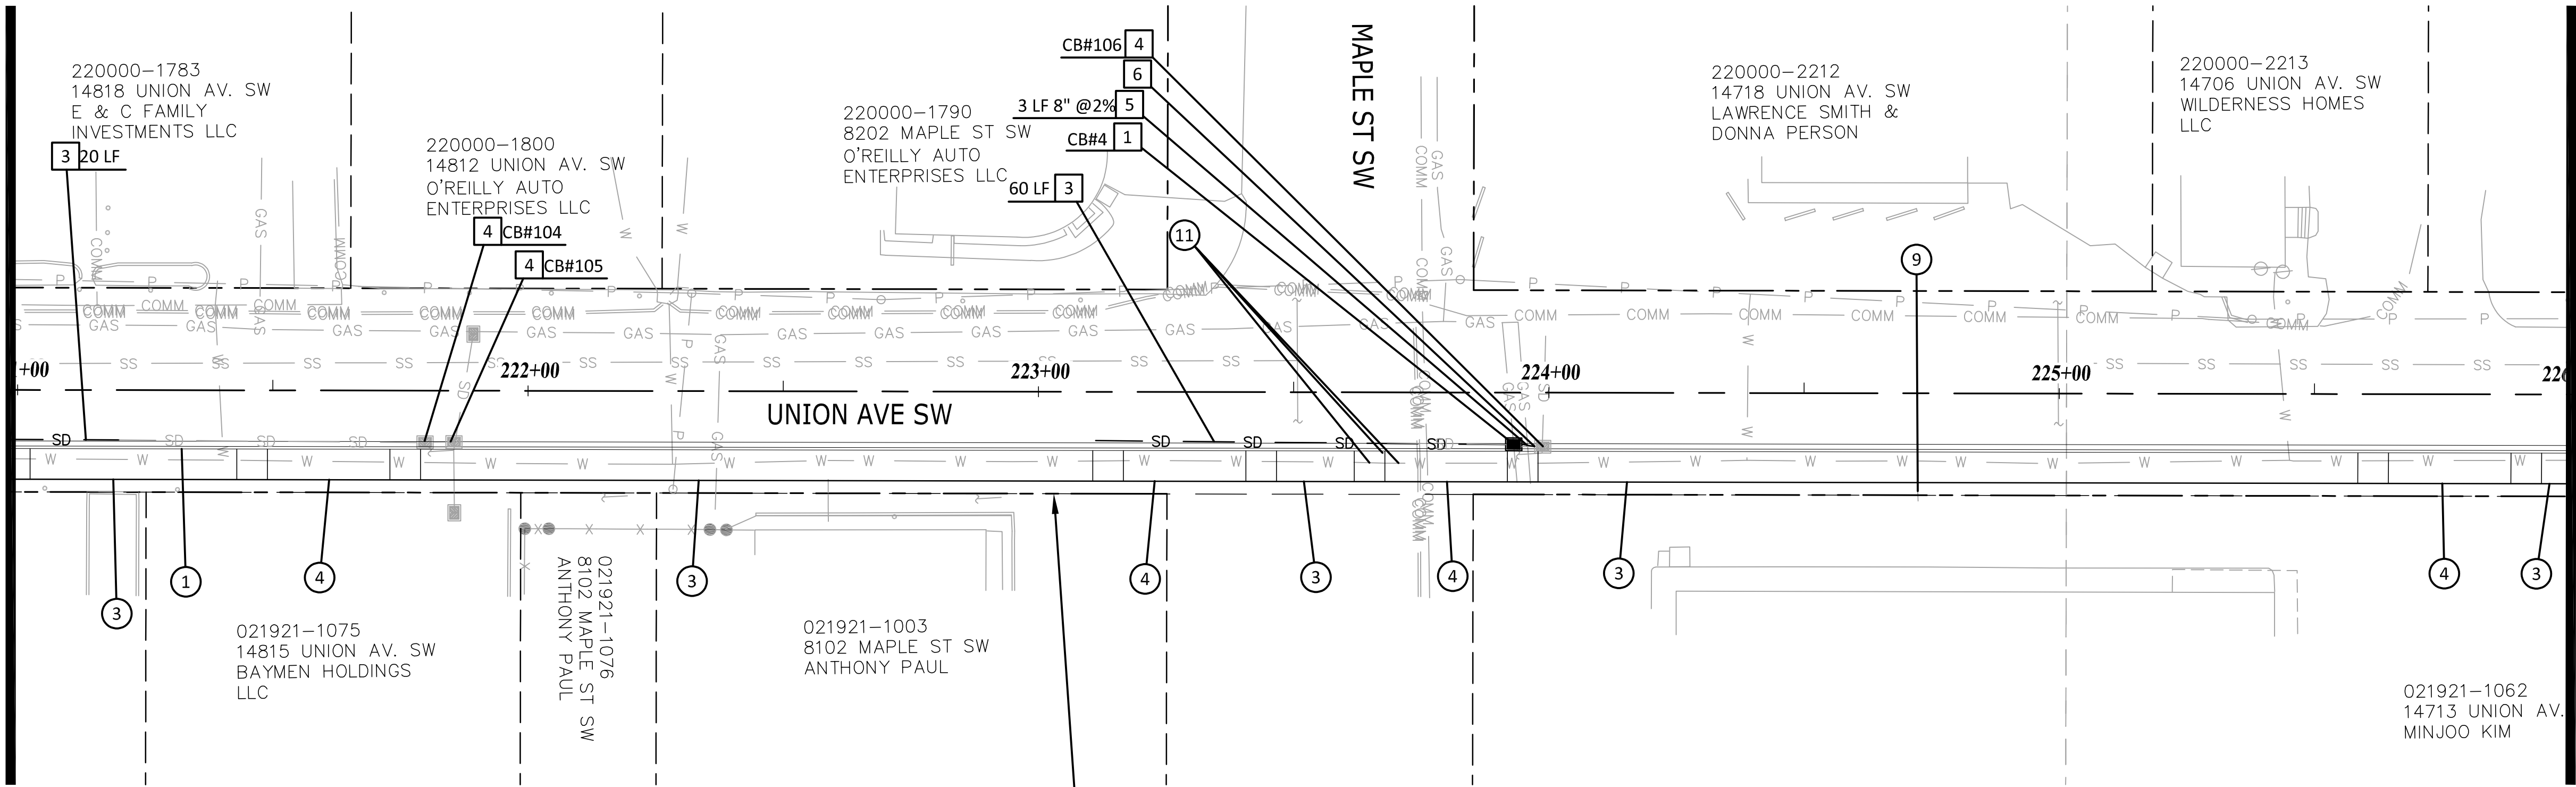

MATCH LINE STA. 226+00
SEE DRAWING PP4

CONSTRUCTION NOTES


- 1 CEMENT CONC. TRAFFIC CURB AND GUTTER PER CITY OF LAKEWOOD STD PLAN FR-04
- 2 CEMENT CONC. PEDESTRIAN CURB PER CITY OF LAKEWOOD STD PLAN FR-04
- 3 CEMENT CONC. SIDEWALK PER CITY OF LAKEWOOD STD PLAN FR-03
- 4 CEMENT CONC. DRIVEWAY ENTRANCE TYPE 1 PER WSDOT STD PLAN F-80.10-04
- 5 CEMENT CONC. CURB RAMP TYPE PARALLEL PER WSDOT STD PLAN F-40.12-03
- 6 ADJUST MANHOLE PER PIERCE COUNTY STD DETAIL 1002A
- 7 ADJUST JUNCTION BOX TO FINISH GRADE
- 8 EXTRUDED CURB PER CITY OF LAKEWOOD STANDARD PLAN FR-04
- 9 ADJUSTMENT OF WATER METER BOX IS BY LAKEWOOD WATER DISTRICT. DISTRICT TO PROVIDE NEW LID. POUR PORTION OF METER IN SIDEWALK.
- 10 PROTECT EXISTING MONUMENT.
- 11 ADJUST VALVE BOX. OBTAIN NEW BOX FROM LAKEWOOD WATER DISTRICT OR PSE.

STORM DRAINAGE NOTES

- 1 INSTALL TYPE 1 CB PER WSDOT STD PLAN B-5.20-03
- 2 INSTALL TYPE 1P CB PER COL STD PLAN SW-03
- 3 INFILTRATION TRENCH PER DETAIL SHEET 4
- 4 ADJUST CATCH BASIN TO FINISH GRADE
- 5 INSTALL SD PIPE PER TYPE AND SLOPE SHOWN
- 6 CONNECT TO EXISTING CB BY REMOVING EXISTING PIPE AND INSTALLING NEW DOWN TURNED 90° ELBOW.

GENERAL NOTES


- 1 ALIGNMENT AND STATIONING PER SURVEYED MONUMENTS, SEE SHEET 3
- 2 CURB ELEVATIONS ARE TO TOP BACK OF CURB


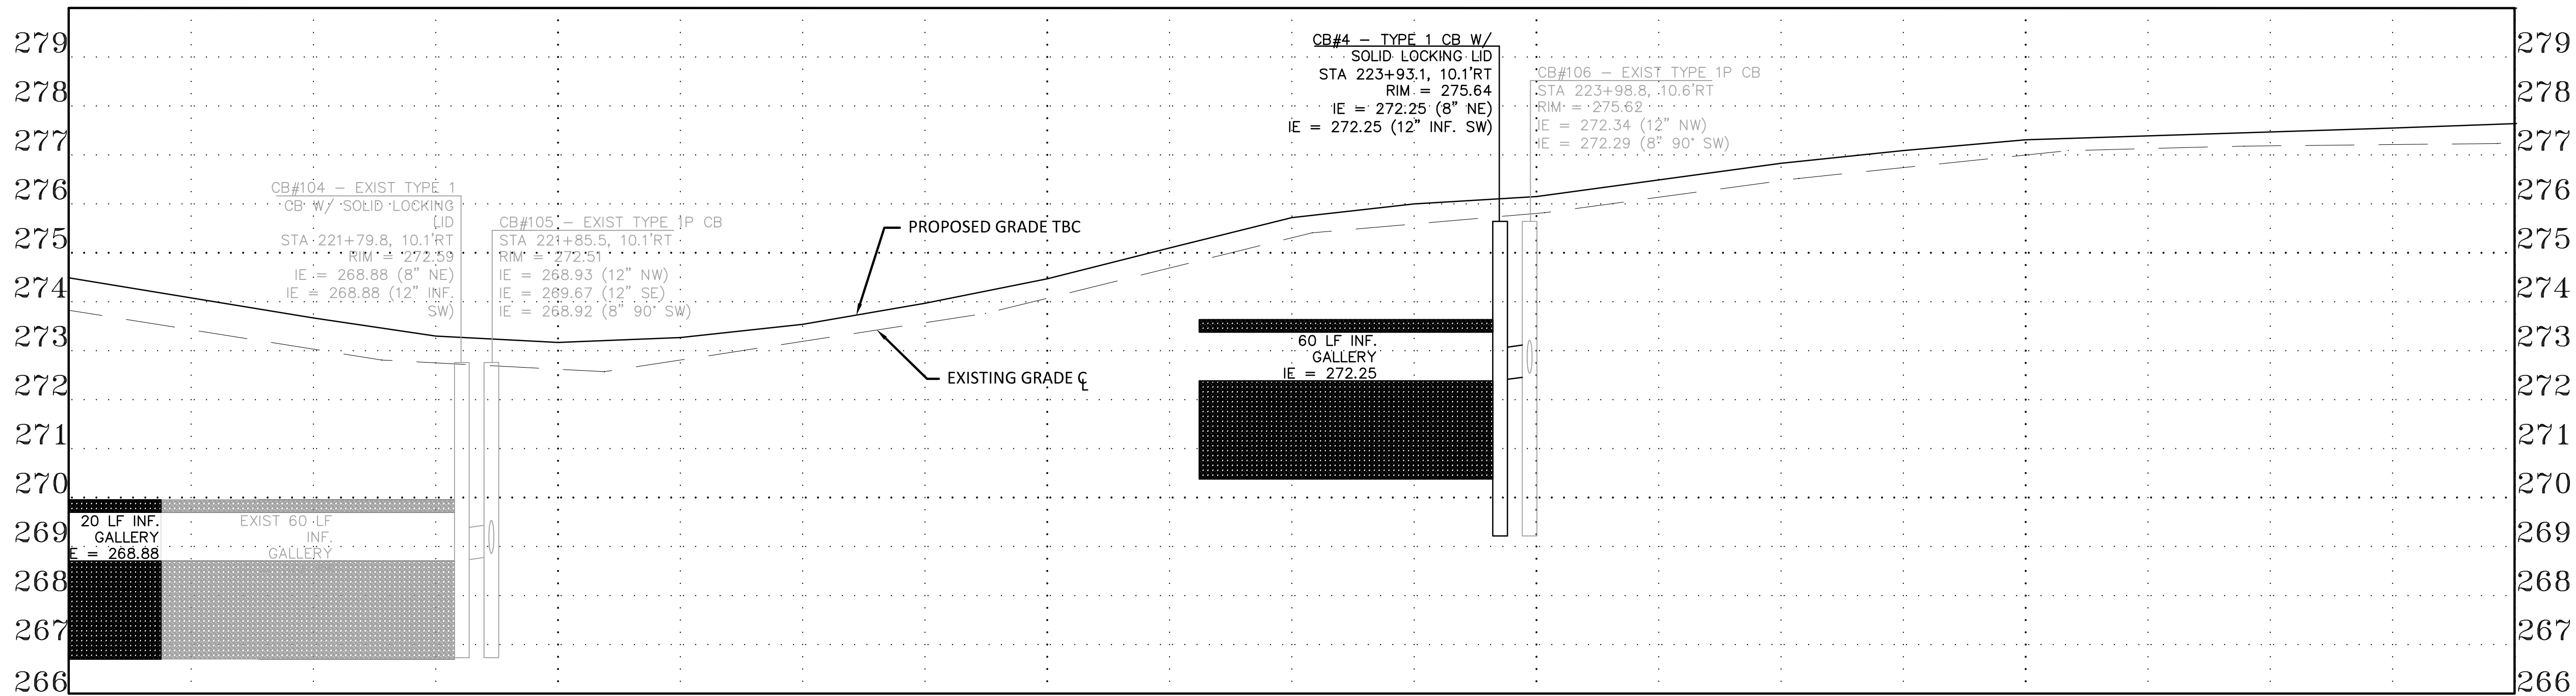


DRIVEWAY SCHEDULE				
ALIGNMENT	STATION	OFFSET	WIDTH	SAWCUT (BACK OF WALK)
UNION	221+61	11.5'RT	24'	2.5'
UNION	223+28	11.5'RT	24'	2.5'
UNION	223+80	11.5'RT	24'	2.5'
UNION	225+76	11.5'RT	24'	2.5'

DRIVEWAY CENTERLINE STATION AND BACK OF CURB OFFSET


LTBC N/A EGCL 273.83' RTBC 274.49'	LTBC N/A EGCL 273.43' RTBC 274.08'	LTBC N/A EGCL 273.03' RTBC 273.67'	LTBC N/A EGCL 272.75' RTBC 273.30'	LTBC N/A EGCL 272.62' RTBC 273.17'	LTBC N/A EGCL 272.81' RTBC 273.27'	LTBC N/A EGCL 273.19' RTBC 273.54'	LTBC N/A EGCL 273.57' RTBC 273.97'	LTBC N/A EGCL 274.07' RTBC 274.47'	LTBC N/A EGCL 274.69' RTBC 275.10'	LTBC N/A EGCL 275.31' RTBC 275.72'	LTBC N/A EGCL 275.59' RTBC 276.00'	LTBC N/A EGCL 275.81' RTBC 276.15'	LTBC N/A EGCL 276.13' RTBC 276.49'	LTBC N/A EGCL 276.47' RTBC 276.83'	LTBC N/A EGCL 276.74' RTBC 277.09'	LTBC N/A EGCL 277.00' RTBC 277.31'	LTBC N/A EGCL 277.13' RTBC 277.39'	LTBC N/A EGCL 277.19' RTBC 277.47'	LTBC N/A EGCL 277.21' RTBC 277.55'	LTBC N/A EGCL 277.26' RTBC 277.64'
221+00	221+25	221+50	221+75	222+00	222+25	222+50	222+75	223+00	223+25	223+50	223+75	224+00	224+25	224+50	224+75	225+00	225+25	225+50	225+75	226+00

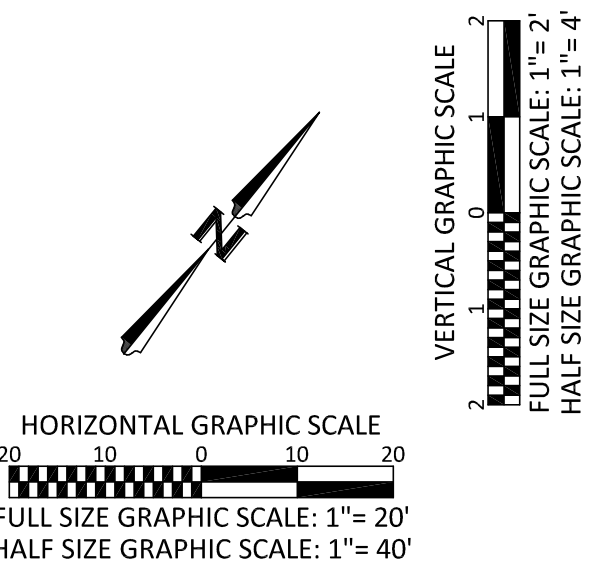

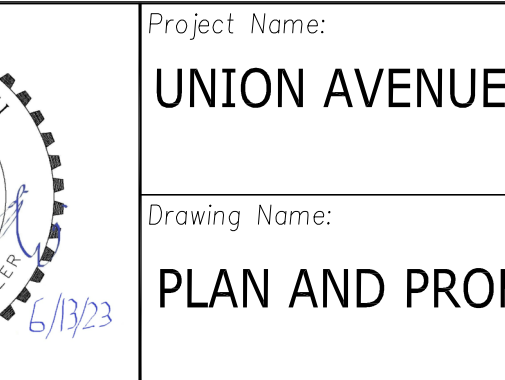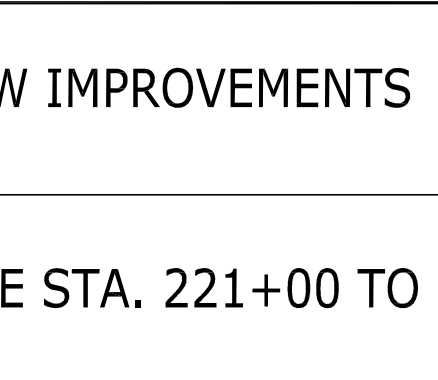No.	Release/Revision	Re. Date	Re. By	Designed By: T. POKSWINSKI			Project Name: UNION AVENUE SW IMPROVEMENTS	Job No. 302.0096
				Entered By: A. DOBROVIDOVA			Drawing No. PP3	
				Checked By: C. T. HILL			Sheet 10 of 20	
				Approved By: P. BUCICH				
				Project Start Date: XX/XX/23 Drawing Scale: AS SHOWN Electronic File Name: 302.0096				

MATCH LINE STA. 226+00
SEE DRAWING PP3

MATCH LINE STA. 231+00
SEE DRAWING PPS

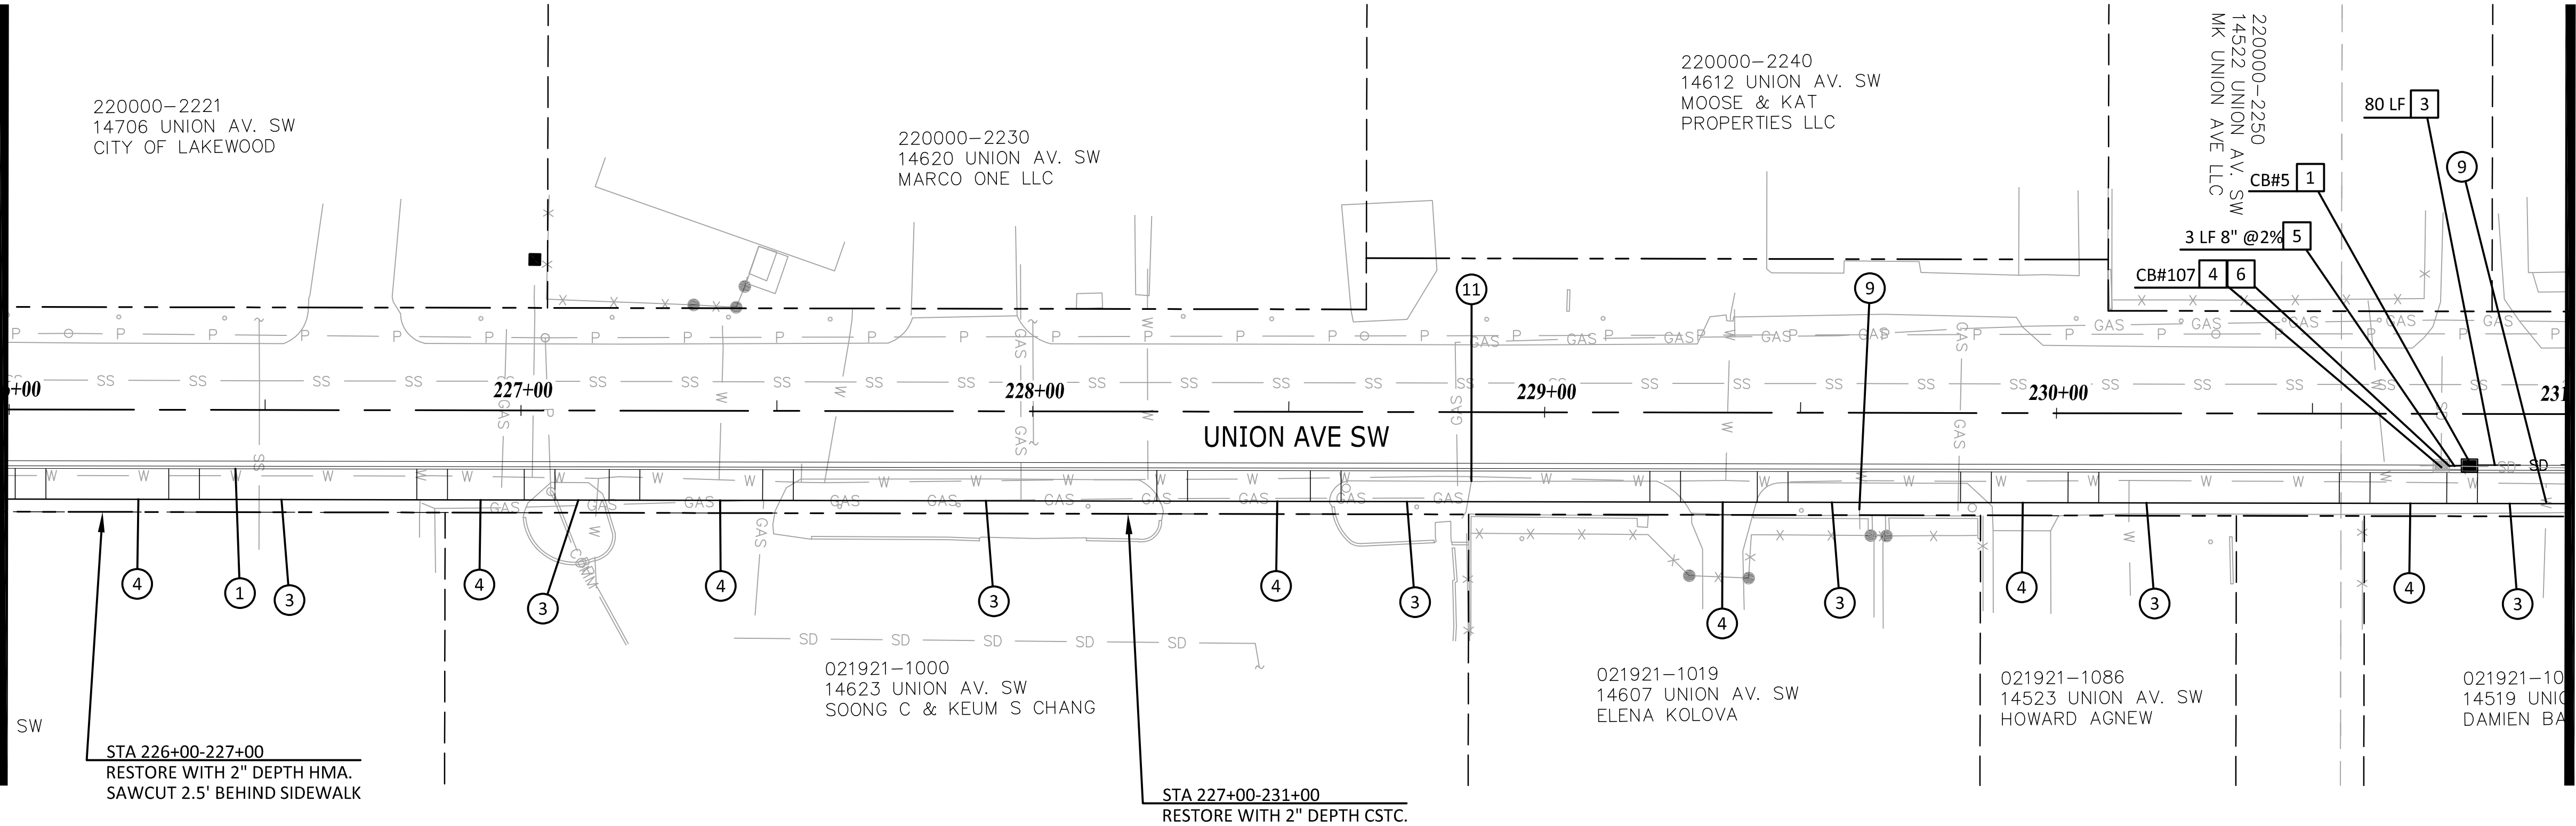

CONSTRUCTION NOTES


- CEMENT CONC. TRAFFIC CURB AND GUTTER PER CITY OF LAKEWOOD STD PLAN FR-04
- CEMENT CONC. PEDESTRIAN CURB PER CITY OF LAKEWOOD STD PLAN FR-04
- CEMENT CONC. SIDEWALK PER CITY OF LAKEWOOD STD PLAN FR-03
- CEMENT CONC. DRIVEWAY ENTRANCE TYPE 1 PER WSDOT STD PLAN F-80.10-04
- CEMENT CONC. CURB RAMP TYPE PARALLEL PER WSDOT STD PLAN F-40.12-03
- ADJUST MANHOLE PER PIERCE COUNTY STD DETAIL 1002A
- ADJUST JUNCTION BOX TO FINISH GRADE
- EXTRUDED CURB PER CITY OF LAKEWOOD STANDARD PLAN FR-04
- ADJUSTMENT OF WATER METER BOX IS BY LAKEWOOD WATER DISTRICT. DISTRICT TO PROVIDE NEW LID. POUR PORTION OF METER IN SIDEWALK.
- PROTECT EXISTING MONUMENT.
- ADJUST VALVE BOX. OBTAIN NEW BOX FROM LAKEWOOD WATER DISTRICT OR PSE.

STORM DRAINAGE NOTES

- INSTALL TYPE 1 CB PER WSDOT STD PLAN B-5.20-03
- INSTALL TYPE 1P CB PER COL STD PLAN SW-03
- INFILTRATION TRENCH PER DETAIL SHEET 4
- ADJUST CATCH BASIN TO FINISH GRADE
- INSTALL SD PIPE PER TYPE AND SLOPE SHOWN
- CONNECT TO EXISTING CB BY REMOVING EXISTING PIPE AND INSTALLING NEW DOWN TURNED 90° ELBOW.

GENERAL NOTES

- ALIGNMENT AND STATIONING PER SURVEYED MONUMENTS, SEE SHEET 3
- CURB ELEVATIONS ARE TO TOP BACK OF CURB

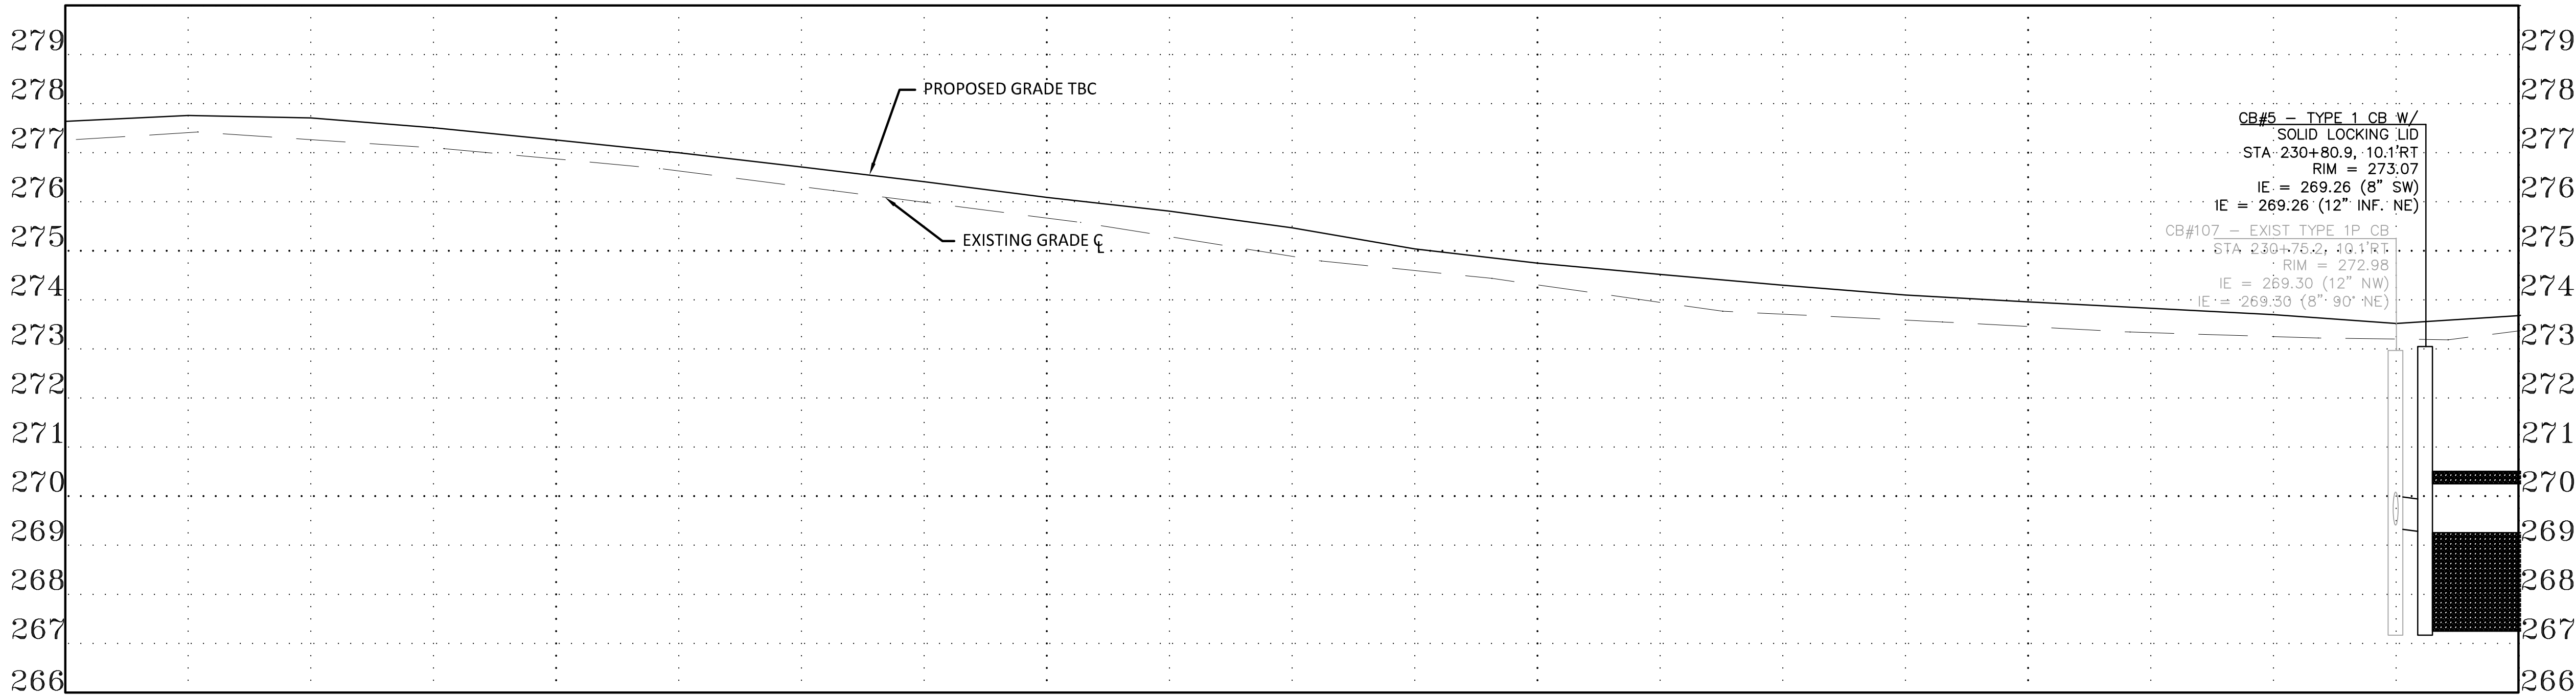


DRIVEWAY SCHEDULE

ALIGNMENT	STATION	OFFSET	WIDTH	SAWCUT (BACK OF WALK)
UNION	226+19	11.5'RT	24'	2.5'
UNION	226+93	11.5'RT	15'	2.5'
UNION	227+35	11.5'RT	24'	2.5'
UNION	228+42	11.5'RT	24'	2.5'
UNION	229+34	11.5'RT	15'	2.5'
UNION	229+94	11.5'RT	15'	2.5'
UNION	230+69	11.5'RT	15'	2.5'


DRIVEWAY CENTERLINE STATION AND BACK OF CURB OFFSET


LTBC N/A EGCL 277.26' RTBC 277.64'	LTBC N/A EGCL 277.41' RTBC 277.76'	LTBC N/A EGCL 277.27' RTBC 277.71'	LTBC N/A EGCL 277.10' RTBC 277.51'	LTBC N/A EGCL 276.87' RTBC 277.26'	LTBC N/A EGCL 276.63' RTBC 277.00'	LTBC N/A EGCL 276.31' RTBC 276.71'	LTBC N/A EGCL 275.99' RTBC 276.41'	LTBC N/A EGCL 275.67' RTBC 276.09'	LTBC N/A EGCL 275.29' RTBC 275.81'	LTBC N/A EGCL 274.89' RTBC 275.47'	LTBC N/A EGCL 274.60' RTBC 275.04'	LTBC N/A EGCL 274.31' RTBC 274.75'	LTBC N/A EGCL 273.95' RTBC 274.52'	LTBC N/A EGCL 273.71' RTBC 274.30'	LTBC N/A EGCL 273.59' RTBC 274.10'	LTBC N/A EGCL 273.46' RTBC 273.96'	LTBC N/A EGCL 273.33' RTBC 273.83'	LTBC N/A EGCL 273.25' RTBC 273.70'	LTBC N/A EGCL 273.20' RTBC 273.52'	LTBC N/A EGCL 273.37' RTBC 273.68'
226+00	226+25	226+50	226+75	227+00	227+25	227+50	227+75	228+00	228+25	228+50	228+75	229+00	229+25	229+50	229+75	230+00	230+25	230+50	230+75	231+00

No.	Release/Revision	Re. Date	Re. By	Designed By: T. POKSWINSKI
▲				Entered By: A. DOBROVIDOVA
▲				Checked By: C. T. HILL
▲				Approved By: P. BUCICH
▲				Project Start Date: Drawing Scale: XX/XX/23 AS SHOWN
▲				Electronic File Name: 302.0096

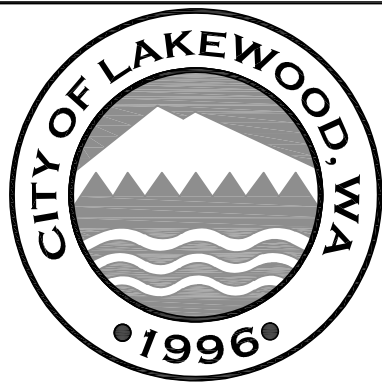


Project Name: UNION AVENUE SW IMPROVEMENTS	Job No. 302.0096
Drawing Name: PLAN AND PROFILE STA. 226+00 TO STA. 231+00	Drawing No. PP4
	Sheet 11 of 20

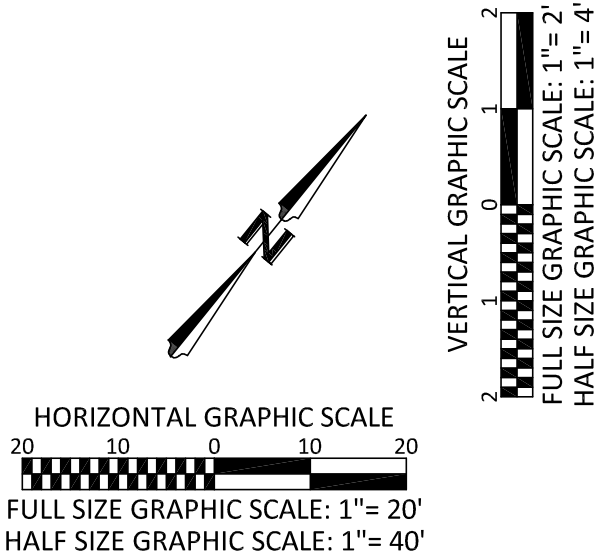

 No.	Release/Revision	Re. Date	Re. By	Designed By: T. POKSWINSKI			Project Name:	Job No.
△				Entered By: A. DOBROVIDOVA			UNION AVENUE SW IMPROVEMENTS	302.0096
△				Checked By: C. T. HILL				Drawing No.
△				Approved By: P. BUCICH				PP5
△				Project Start Date: XX/XX/23			Drawing Name:	PLAN AND PROFILE STA. 231+00 TO STA. 236+15
△				Drawing Scale: AS SHOWN				
				Electronic File Name: 302.0096			Sheet 12 of 20	

MATCH LINE STA. 236+15
SEE DRAWING PP5

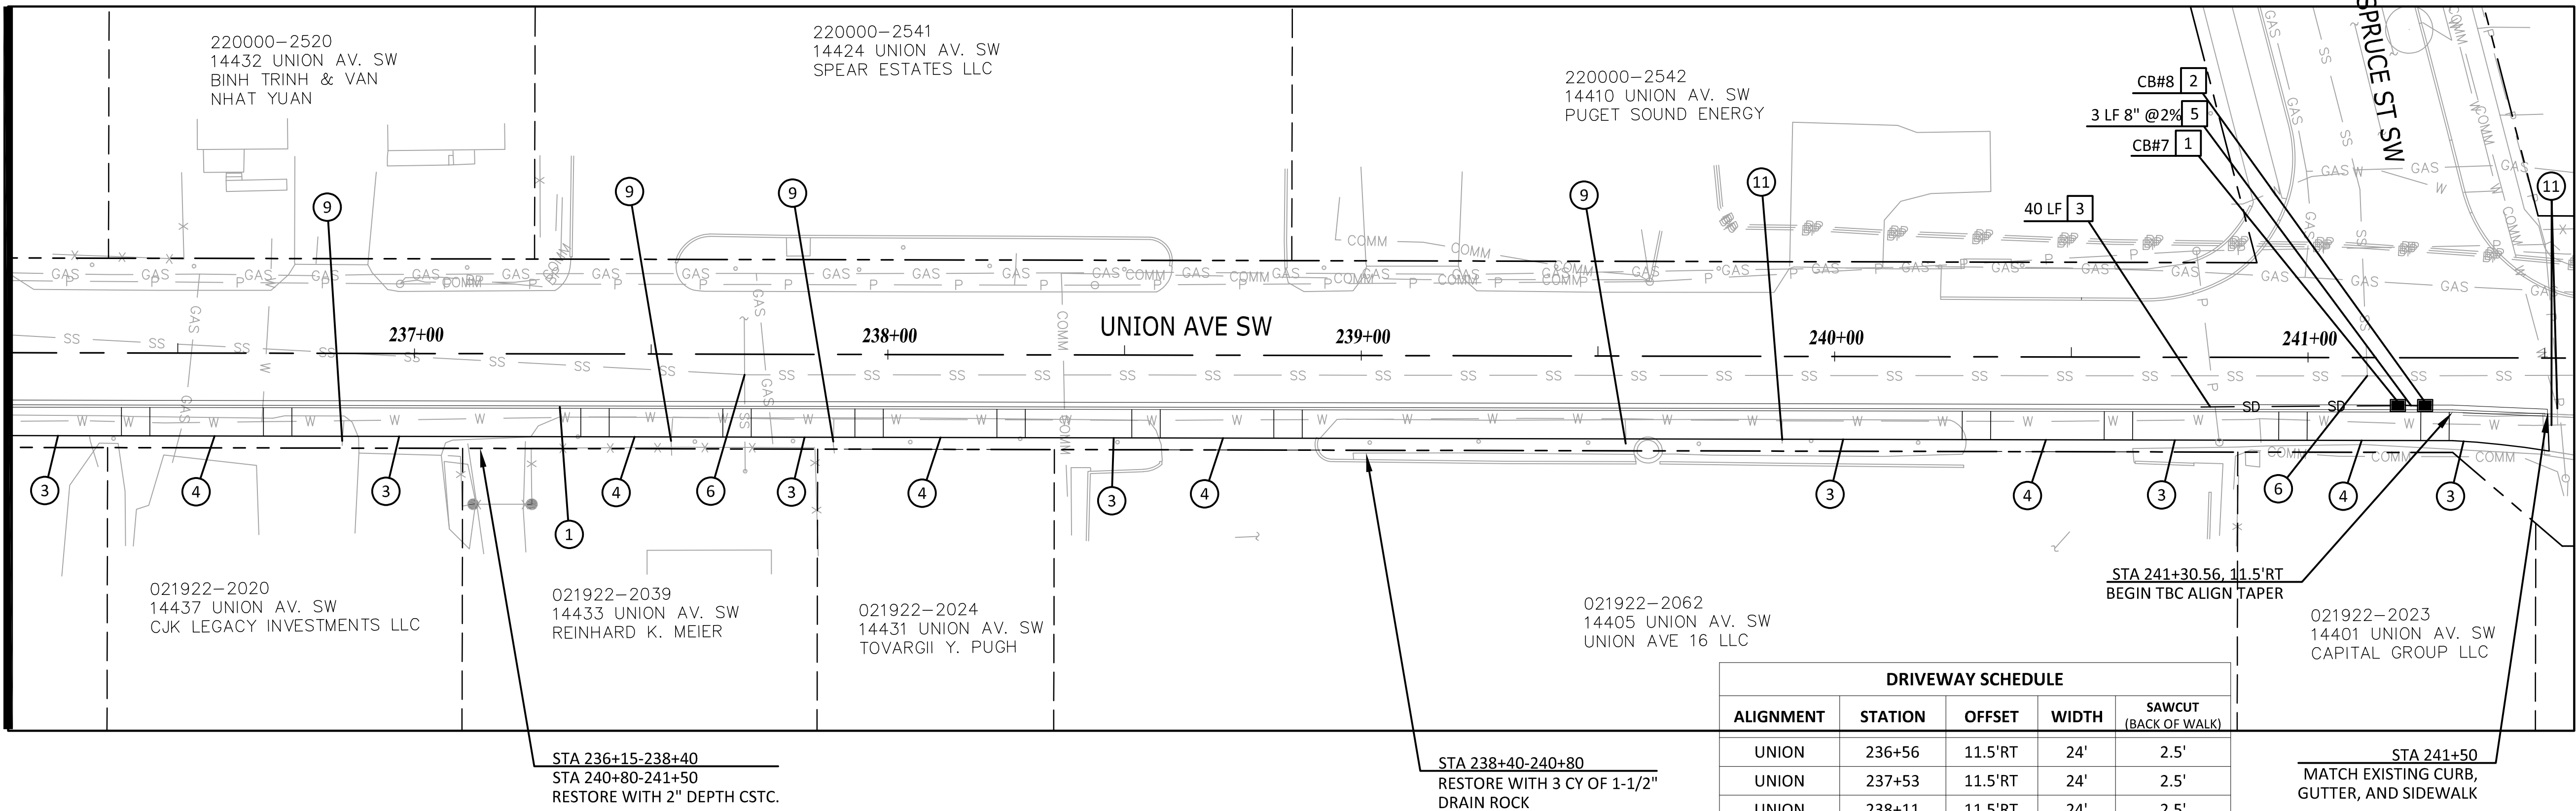

DRIVEWAY SCHEDULE				
ALIGNMENT	STATION	OFFSET	WIDTH	SAWCUT (BACK OF WALK)
UNION	236+56	11.5'RT	24'	2.5'
UNION	237+53	11.5'RT	24'	2.5'
UNION	238+11	11.5'RT	24'	2.5'
UNION	238+70	11.5'RT	24'	2.5'
UNION	240+45	11.5'RT	24'	2.5'
UNION	241+12	11.5'RT	24'	2.5'
DRIVEWAY CENTERLINE STATION AND BACK OF CURB OFFSET				

CONSTRUCTION NOTES


- CEMENT CONC. TRAFFIC CURB AND GUTTER PER CITY OF LAKEWOOD STD PLAN FR-04
- CEMENT CONC. PEDESTRIAN CURB PER CITY OF LAKEWOOD STD PLAN FR-04
- CEMENT CONC. SIDEWALK PER CITY OF LAKEWOOD STD PLAN FR-03
- CEMENT CONC. DRIVEWAY ENTRANCE TYPE 1 PER WSDOT STD PLAN F-80.10-04
- CEMENT CONC. CURB RAMP TYPE PARALLEL PER WSDOT STD PLAN F-40.12-03
- ADJUST MANHOLE PER PIERCE COUNTY STD DETAIL 1002A
- ADJUST JUNCTION BOX TO FINISH GRADE
- EXTRUDED CURB PER CITY OF LAKEWOOD STANDARD PLAN FR-04
- ADJUSTMENT OF WATER METER BOX IS BY LAKEWOOD WATER DISTRICT. DISTRICT TO PROVIDE NEW LID. POUR PORTION OF METER IN SIDEWALK.
- PROTECT EXISTING MONUMENT.
- ADJUST VALVE BOX. OBTAIN NEW BOX FROM LAKEWOOD WATER DISTRICT OR PSE.

STORM DRAINAGE NOTES


- INSTALL TYPE 1 CB PER WSDOT STD PLAN B-5.20-03
- INSTALL TYPE 1P CB PER COL STD PLAN SW-03
- INFILTRATION TRENCH PER DETAIL SHEET 4
- ADJUST CATCH BASIN TO FINISH GRADE
- INSTALL SD PIPE PER TYPE AND SLOPE SHOWN
- CONNECT TO EXISTING CB BY REMOVING EXISTING PIPE AND INSTALLING NEW DOWN TURNED 90° ELBOW.

GENERAL NOTES


- ALIGNMENT AND STATIONING PER SURVEYED MONUMENTS, SEE SHEET 3
- CURB ELEVATIONS ARE TO TOP BACK OF CURB

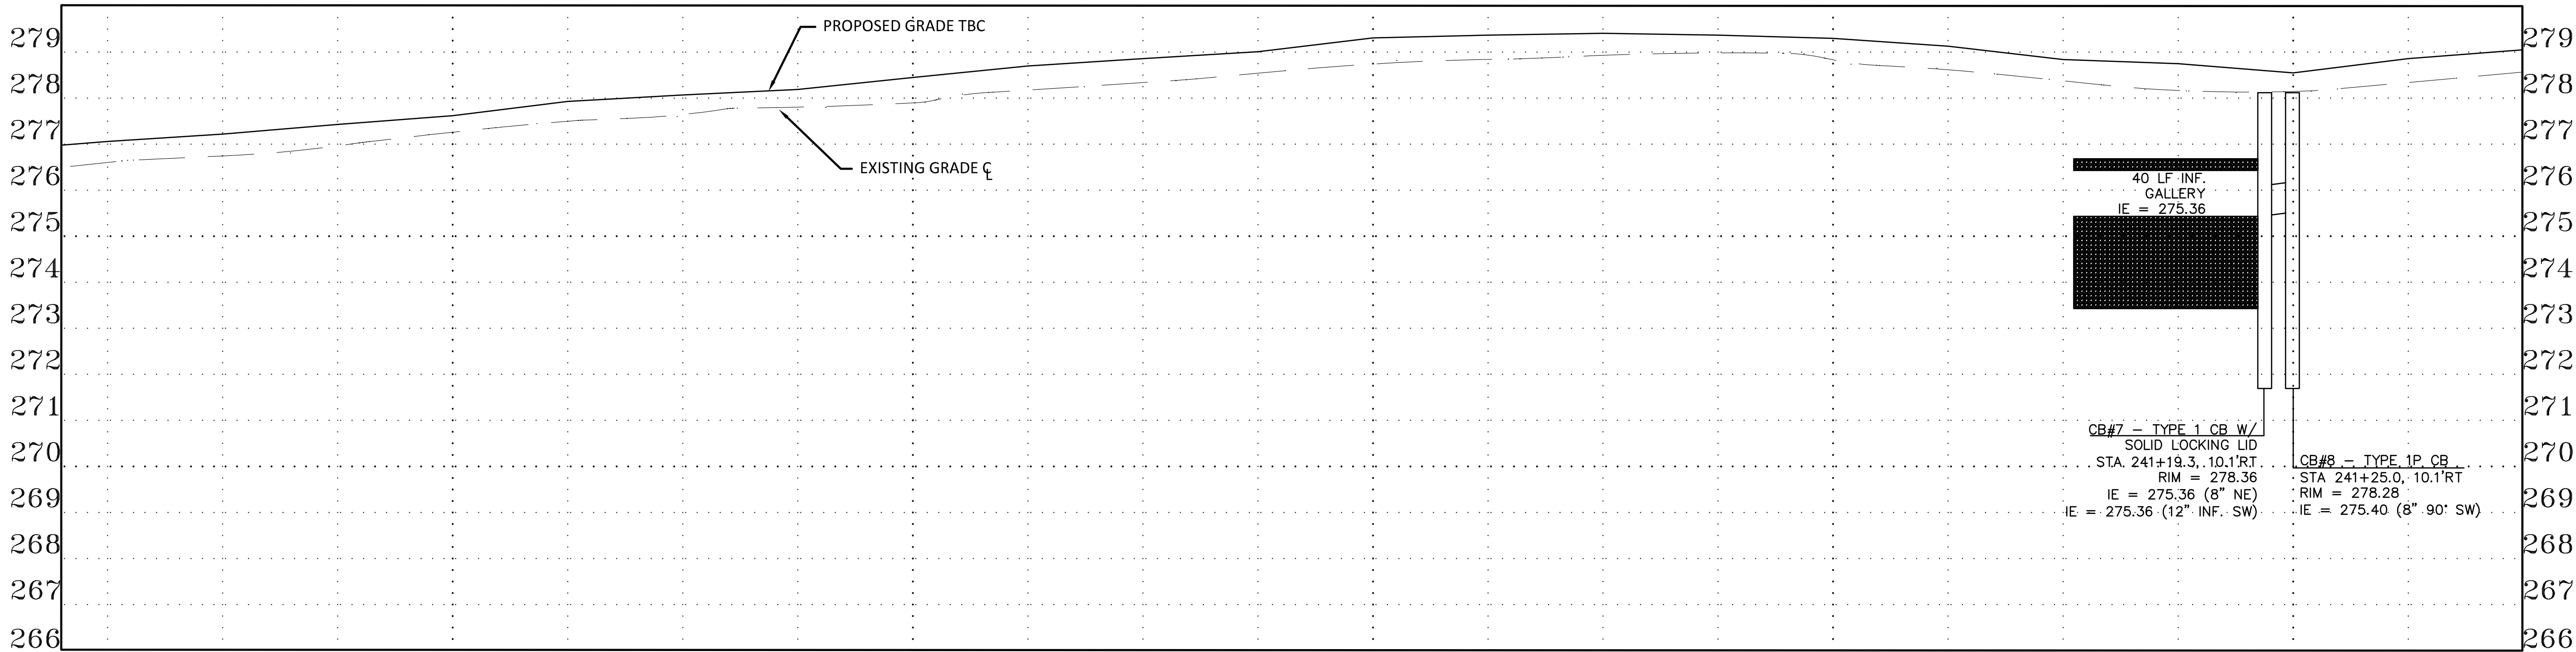

LTBC N/A EGCL 276.60' RTBC 277.06'	LTBC N/A EGCL 276.74' RTBC 277.22'	LTBC N/A EGCL 276.96' RTBC 277.43'	LTBC N/A EGCL 277.26' RTBC 277.62'	LTBC N/A EGCL 277.50' RTBC 277.93'	LTBC N/A EGCL 277.64' RTBC 278.07'	LTBC N/A EGCL 277.80' RTBC 278.19'	LTBC N/A EGCL 277.90' RTBC 278.45'	LTBC N/A EGCL 278.18' RTBC 278.70'	LTBC N/A EGCL 278.34' RTBC 278.86'	LTBC N/A EGCL 278.54' RTBC 279.01'	LTBC N/A EGCL 278.74' RTBC 279.31'	LTBC N/A EGCL 278.84' RTBC 279.37'	LTBC N/A EGCL 278.93' RTBC 279.41'	LTBC N/A EGCL 278.98' RTBC 279.37'	LTBC N/A EGCL 278.83' RTBC 279.30'	LTBC N/A EGCL 278.62' RTBC 279.13'	LTBC N/A EGCL 278.38' RTBC 278.84'	LTBC N/A EGCL 278.17' RTBC 278.75'	LTBC N/A EGCL 278.14' RTBC 278.55'	LTBC N/A EGCL 278.34' RTBC 278.86'	LTBC N/A EGCL 278.57' RTBC 279.05'
236+25	236+50	236+75	237+00	237+25	237+50	237+75	238+00	238+25	238+50	238+75	239+00	239+25	239+50	239+75	240+00	240+25	240+50	240+75	241+00	241+25	241+50

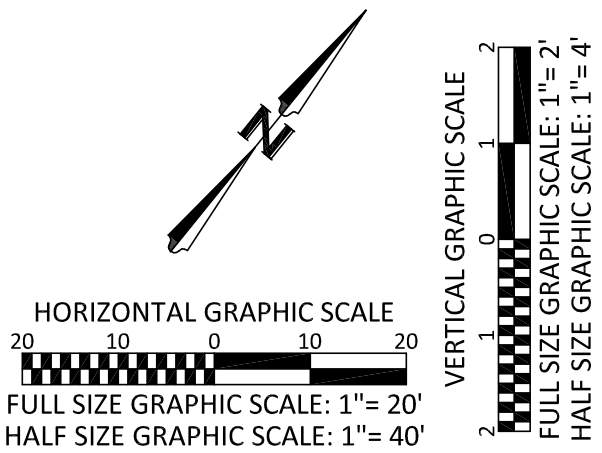


No.	Release/Revision	Re. Date	Re. By	Designed By: T. POKSWINSKI			Project Name: UNION AVENUE SW IMPROVEMENTS	Job No. 302.0096
				Entered By: A. DOBROVIDOVA			Drawing Name: PLAN AND PROFILE STA. 236+15 TO STA. 241+55	Drawing No. PP6
				Checked By: C. T. HILL				Sheet 13
				Approved By: P. BUCICH				of 20
				Project Start Date: XX/XX/23				
				Drawing Scale: AS SHOWN				
				Electronic File Name: 302.0096				

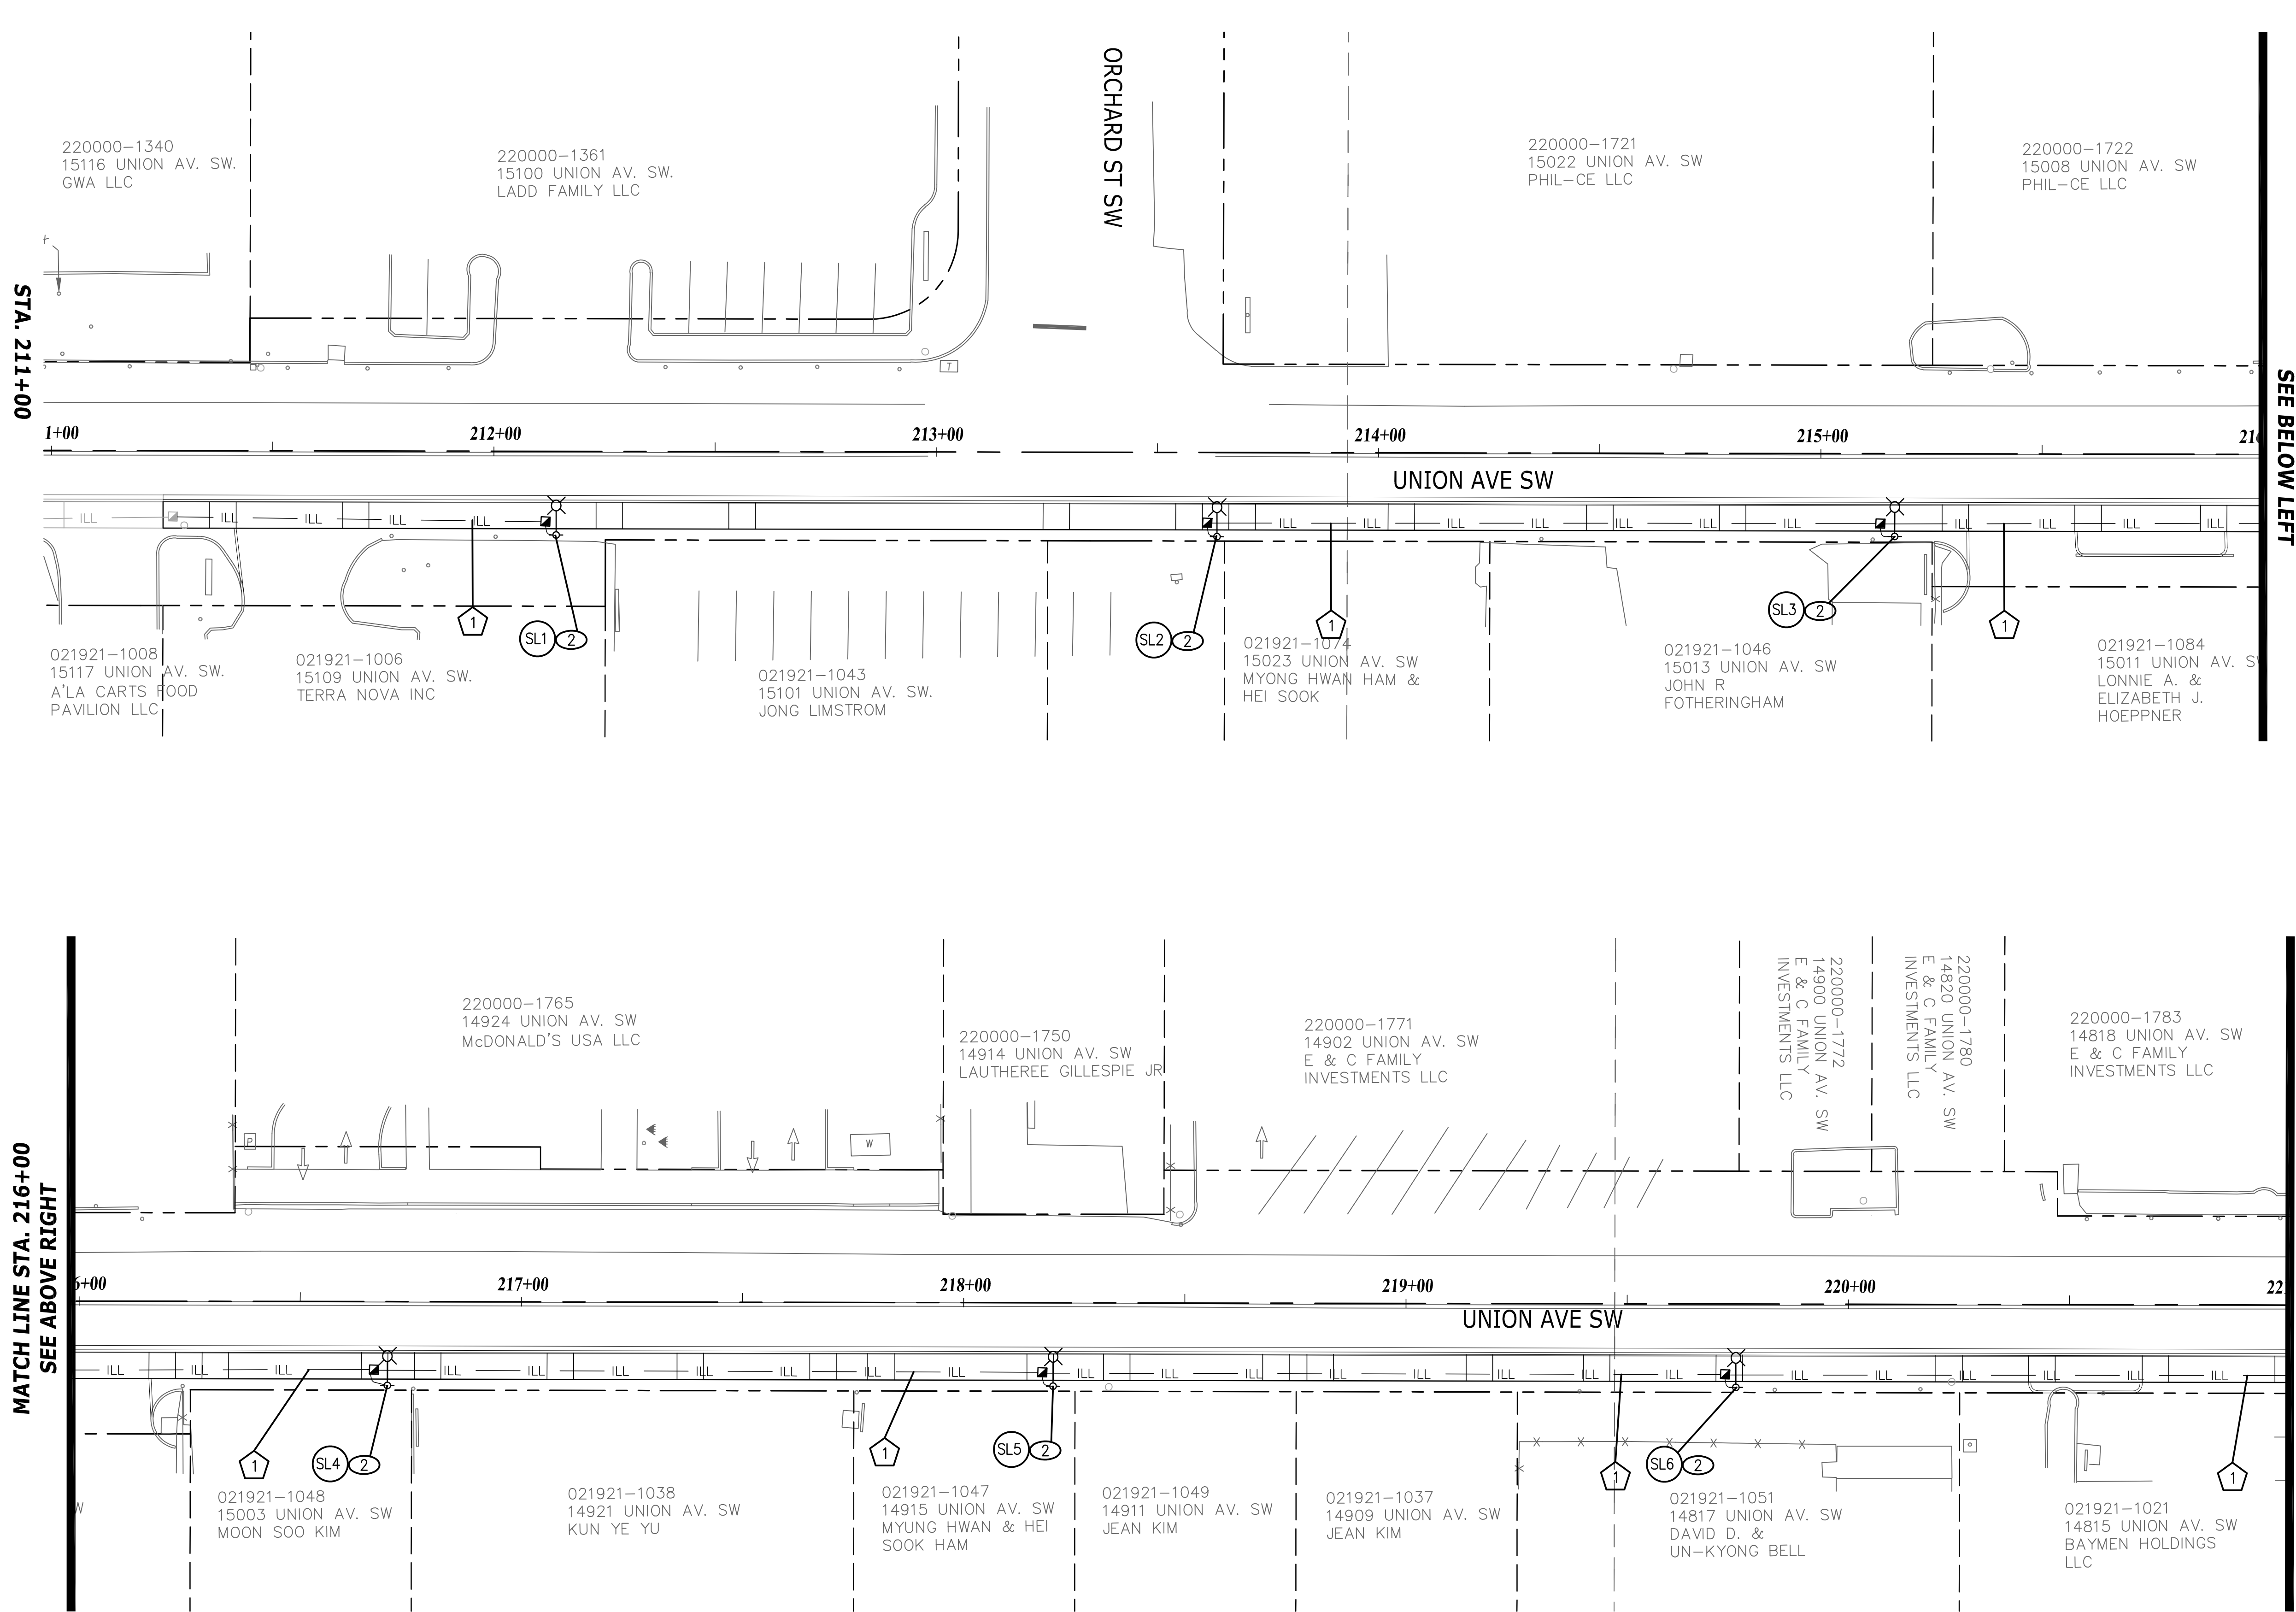


- CHANNELIZATION/ILLUMINATION NOTES**
- 1 PLASTIC CROSSWALK LINE PER WSDOT STD PLAN M-15.10-01
 - 2 LIGHT STANDARD FOUNDATION & JUNCTION BOX PER LAKEWOOD STD PLAN IS-02
 - 3 INSTALL 100 AMP METER SERVICE PER CITY OF LAKEWOOD STD PLAN IS-07

LUMINAIRE SCHEDULE						
SL#	ALIGN	STATION	OFFSET	HEIGHT	MAST ARM	HEAD WATTAGE
1	UNION	212+15	18.75' RT	35'	8'	85
2	UNION	213+65	18.75' RT	35'	8'	85
3	UNION	215+15	18.75' RT	35'	8'	85
4	UNION	216+65	18.75' RT	35'	8'	85
5	UNION	218+18	18.75' RT	35'	8'	85
6	UNION	219+73	18.75' RT	35'	8'	85
ALL POLE FOUNDATIONS SHALL BE 2' IN DIAMETER, 4' DEEP.						


CONDUIT AND WIRING SCHEDULE			
NO.	CONDUIT	SYSTEM	CONDUCTORS
1	(1) - 2"	ILLUMINATION	2 - #6, GRND
NOTES: 1. MINIMUM 2' COVER			

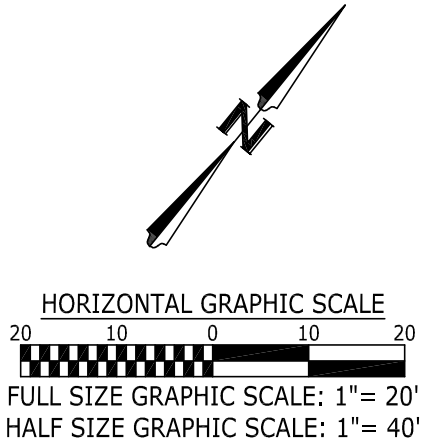



No.	Release/Revision	Re. Date	Re. By	Designed By: T. POKSWINSKI			Project Name: UNION AVENUE SW IMPROVEMENTS	Job No. 302.0096
				Entered By: A. DOBROVIDOVA			Drawing Name: ILLUM./CHANNELIZATION PLAN - STA. 211+00 TO STA. 221+00	Drawing No. IC1
				Checked By: C. T. HILL				Sheet 14 of 20
				Approved By: P. BUCICH				
				Project Start Date: XX/XX/23				
				Drawing Scale: AS SHOWN				
				Electronic File Name: 302.0096				

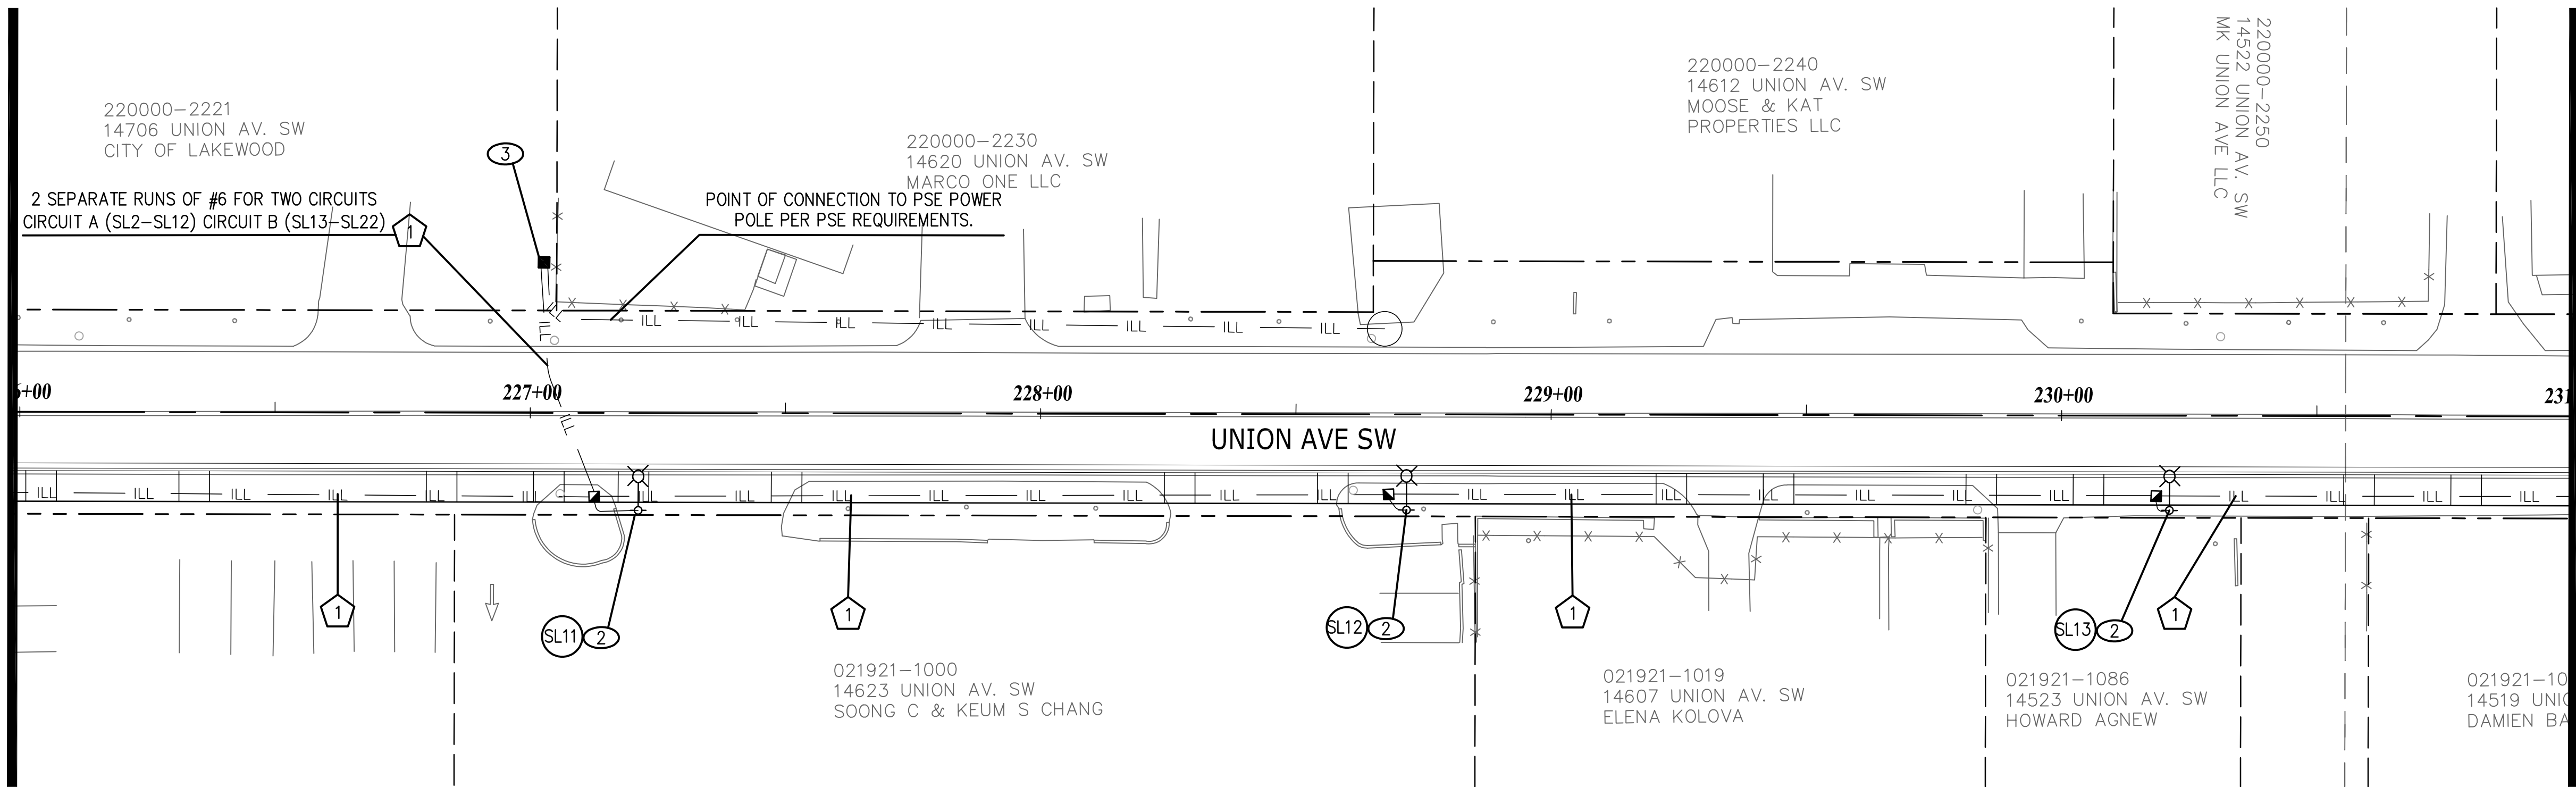


- NOTES: 1. MINIMUM 2' COVER

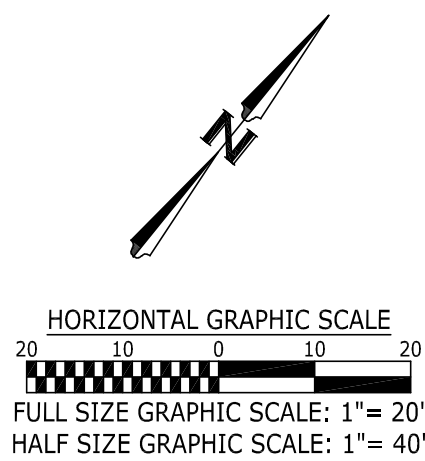


No.	Release/Revision	Re. Date	Re. By	Designed By:			Project Name:	Job No.
△				T. POKSWINSKI			UNION AVENUE SW IMPROVEMENTS	302.0096
△				Entered By: A. DOBROVIDOVA				Drawing No.
△				Checked By: C. T. HILL				IC2
△				Approved By: P. BUCICH			Drawing Name:	Sheet of
△				Project Start Date: XX/XX/23 Drawing Scale: AS SHOWN			ILLUM./CHANNELIZATION PLAN - STA. 221+00 TO STA. 231+00	15 of 20
△				Electronic File Name: 302.0096				

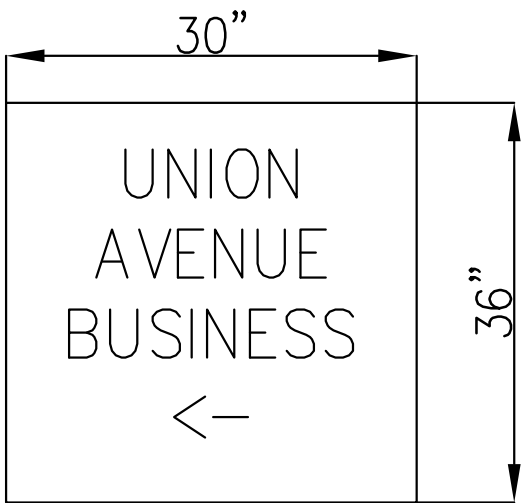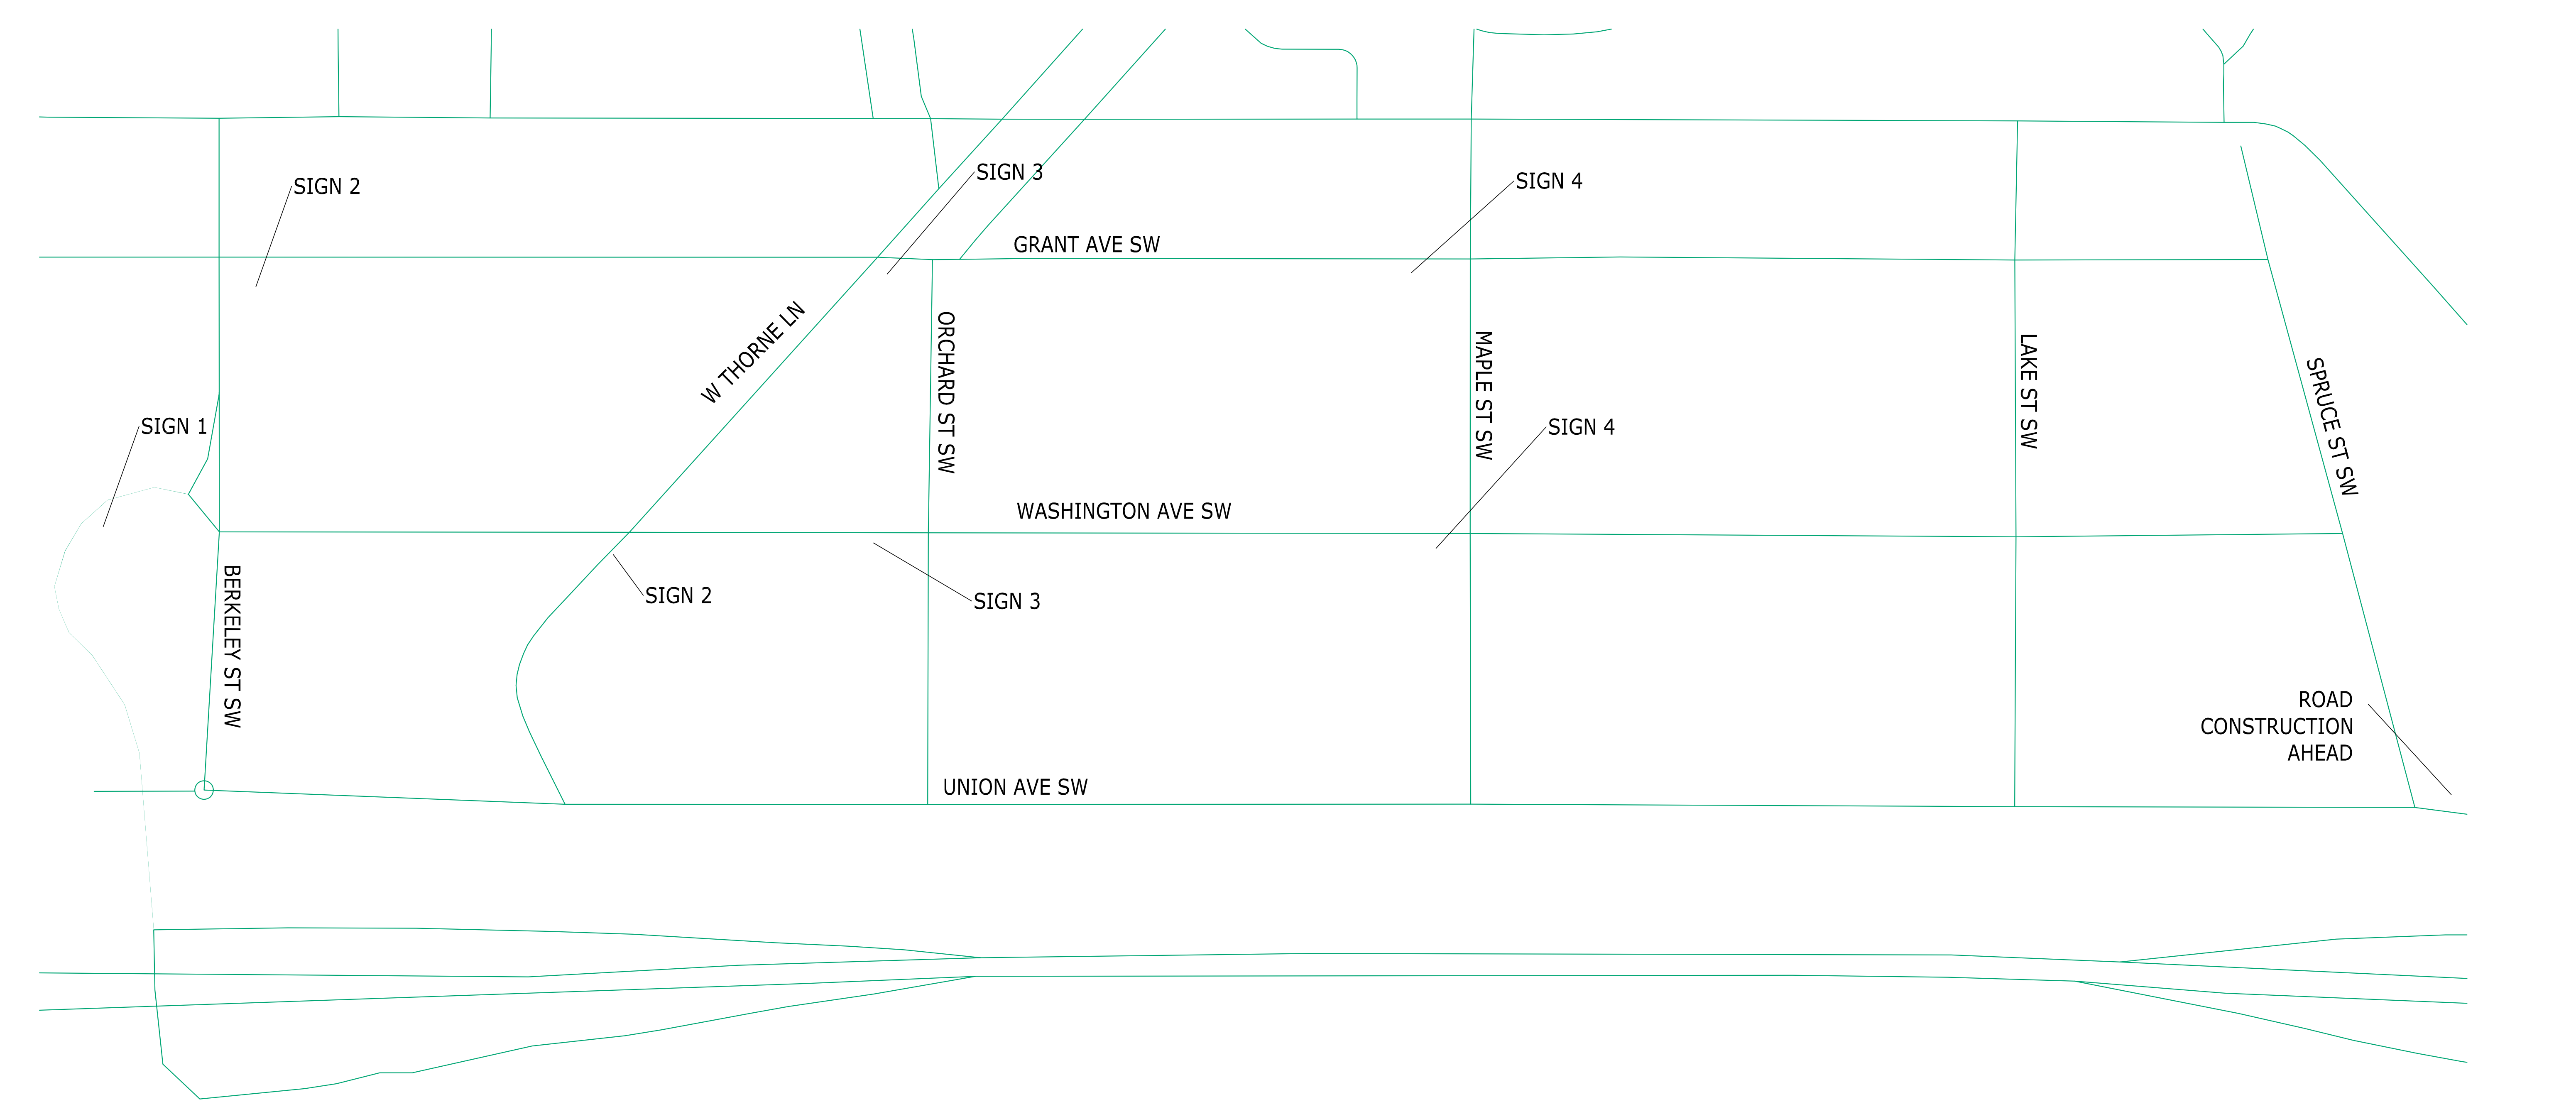


SIGN 1
THERE IS ONE OF THESE SIGNS

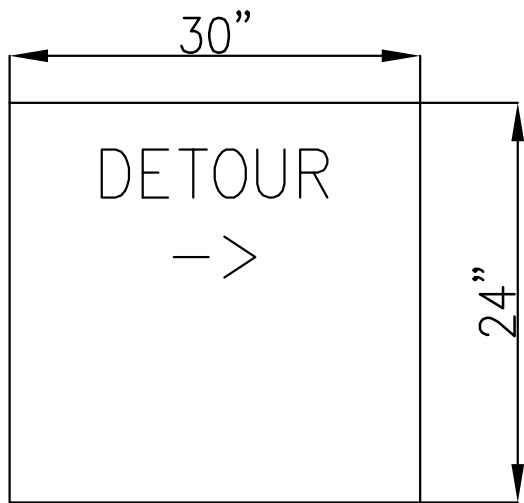


SIGN 2
THERE ARE TWO OF THESE SIGNS

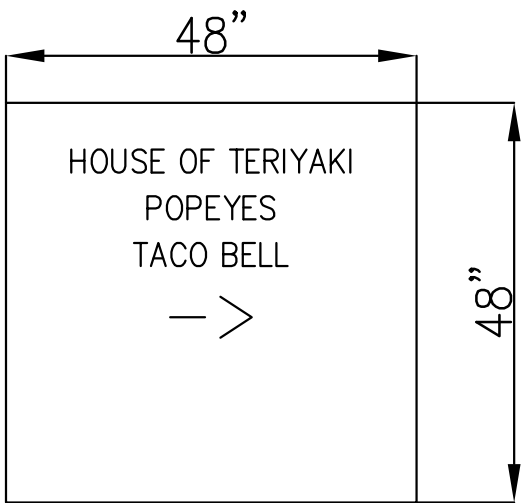



SIGN 3
THERE ARE TWO OF THESE SIGNS

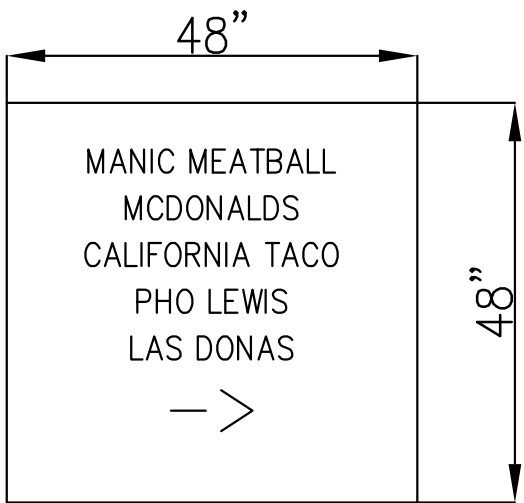

SIGN 4
THERE ARE TWO OF THESE SIGNS

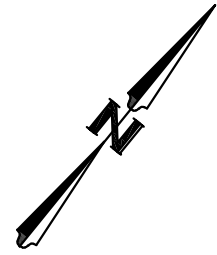


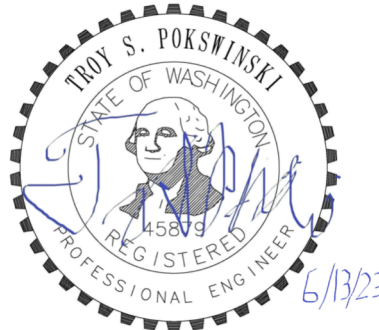No.	Release/Revision	Re. Date	Re. By	Designed By: T. POKSWINSKI			Project Name: UNION AVENUE SW IMPROVEMENTS	Job No. 302.0096
				Entered By: A. DOBROVIDOVA				
				Checked By: C. T. HILL				Drawing No. TC1
				Approved By: P. BUCICH			Drawing Name:	Sheet of
				Project Start Date: XX/XX/23			TRAFFIC CONTROL PLAN - EXTERIOR SIGNAGE	17 of 20
				Drawing Scale: AS SHOWN				
				Electronic File Name: 302.0096				

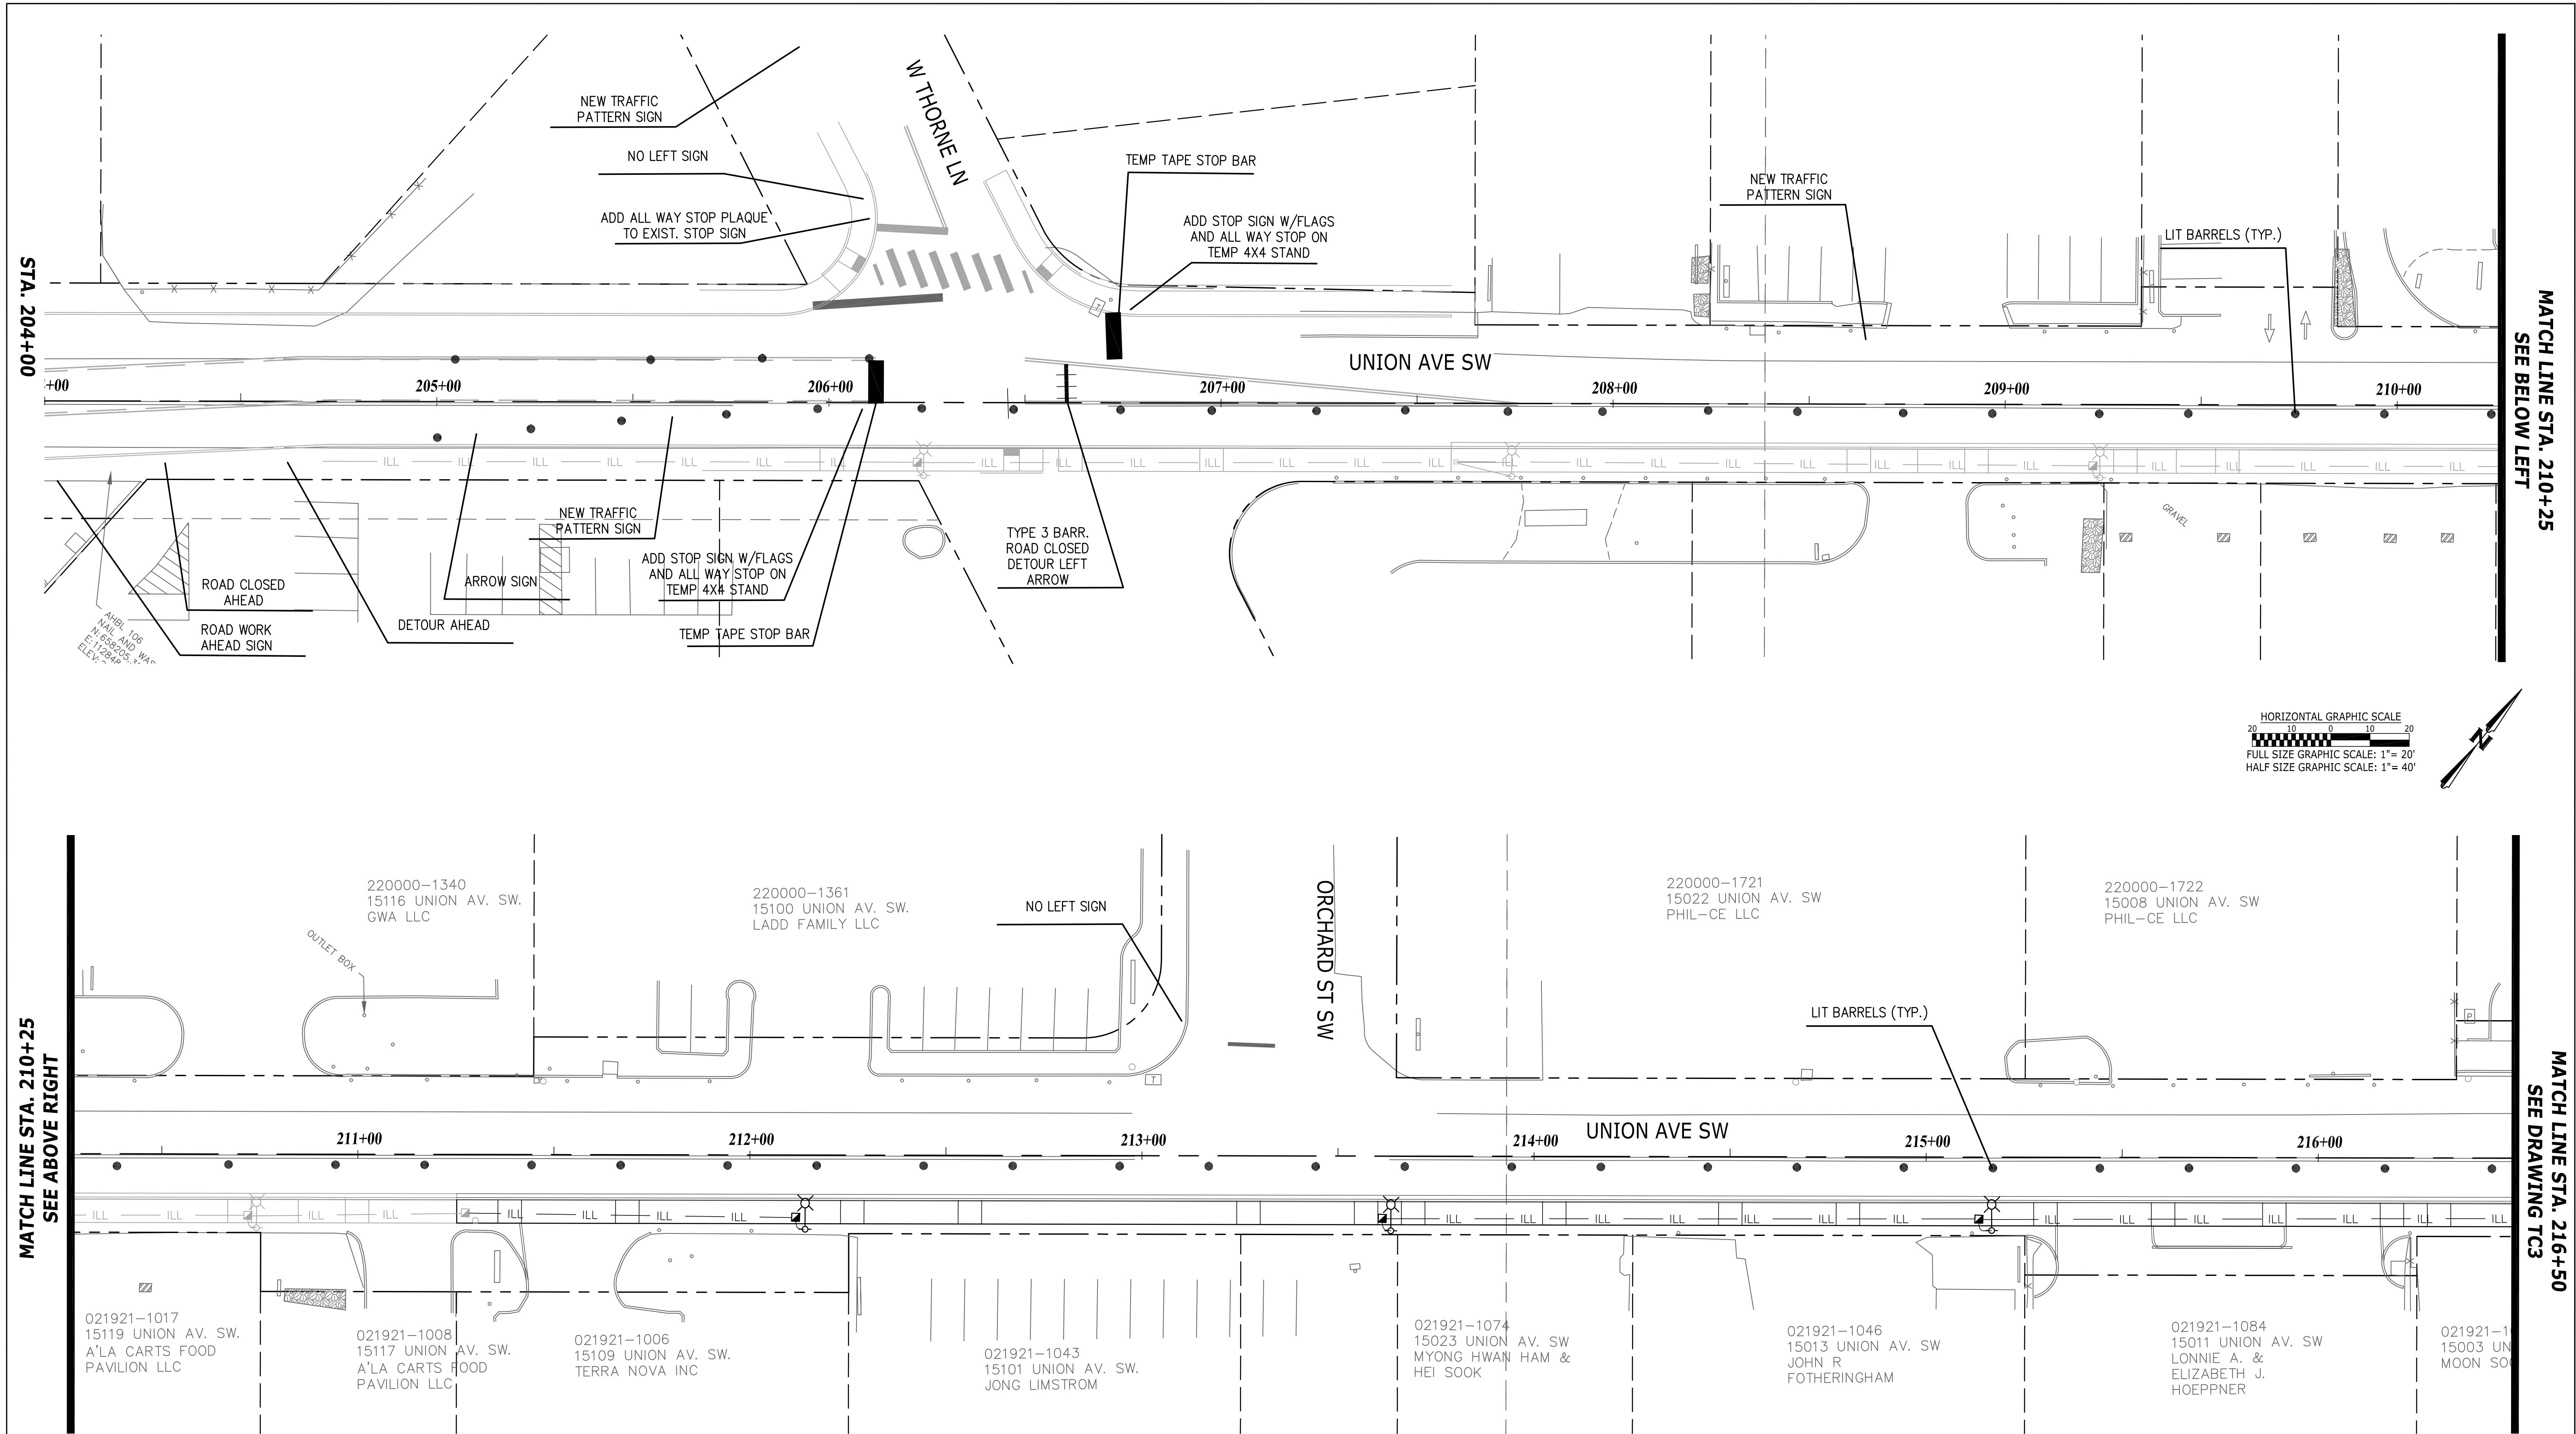


No.	Release/Revision	Re. Date	Re. By	Designed By:	Project Name:	Job No.
▲				T. POKSWINSKI	UNION AVENUE SW IMPROVEMENTS	302.0096
▲				Entered By: A. DOBROVIDOVA		Drawing No.
▲				Checked By: C. T. HILL		TC2
▲				Approved By: P. BUCICH	Drawing Name:	Sheet of
▲				Project Start Date: XX/XX/23 Drawing Scale: AS SHOWN	TRAFFIC CONTROL PLAN - STA. 204+00 TO STA. 216+50	18 of 20
▲				Electronic File Name: 302.0096		

MATCH LINE STA. 216+50
SEE DRAWING TC2

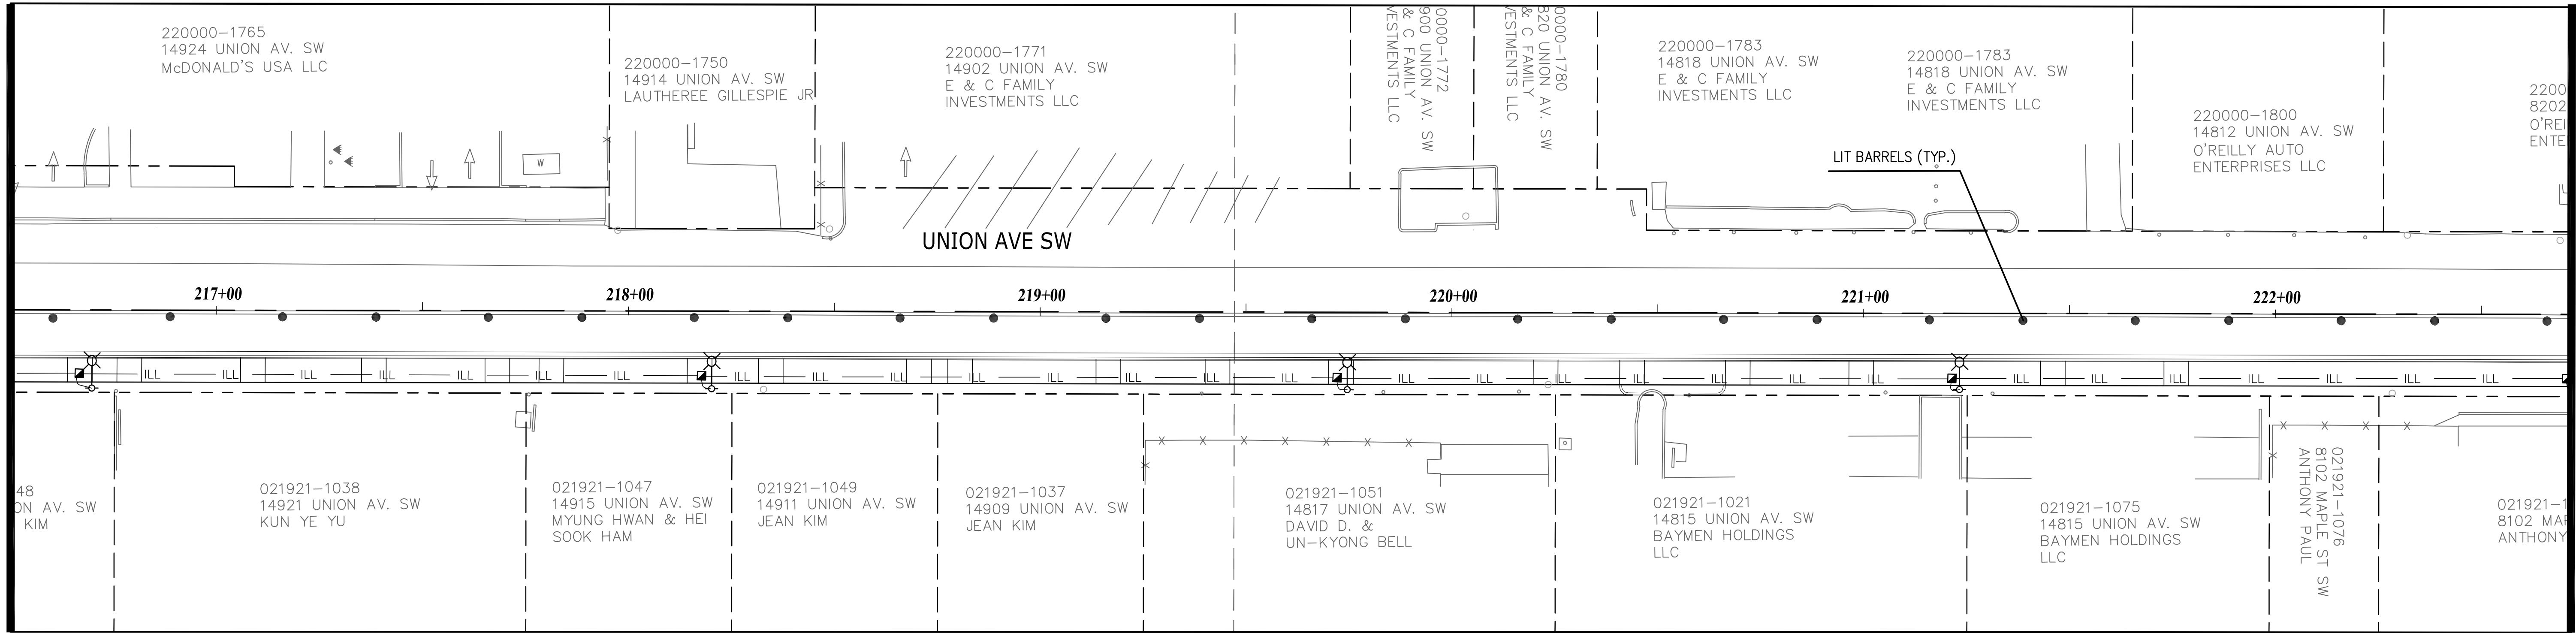


MATCH LINE STA. 222+75
SEE BELOW LEFT


HORIZONTAL GRAPHIC SCALE
20 10 0 10 20
FULL SIZE GRAPHIC SCALE: 1"= 20'
HALF SIZE GRAPHIC SCALE: 1"= 40'


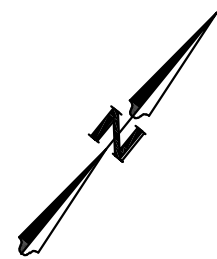




MATCH LINE STA. 222+75
SEE ABOVE RIGHT

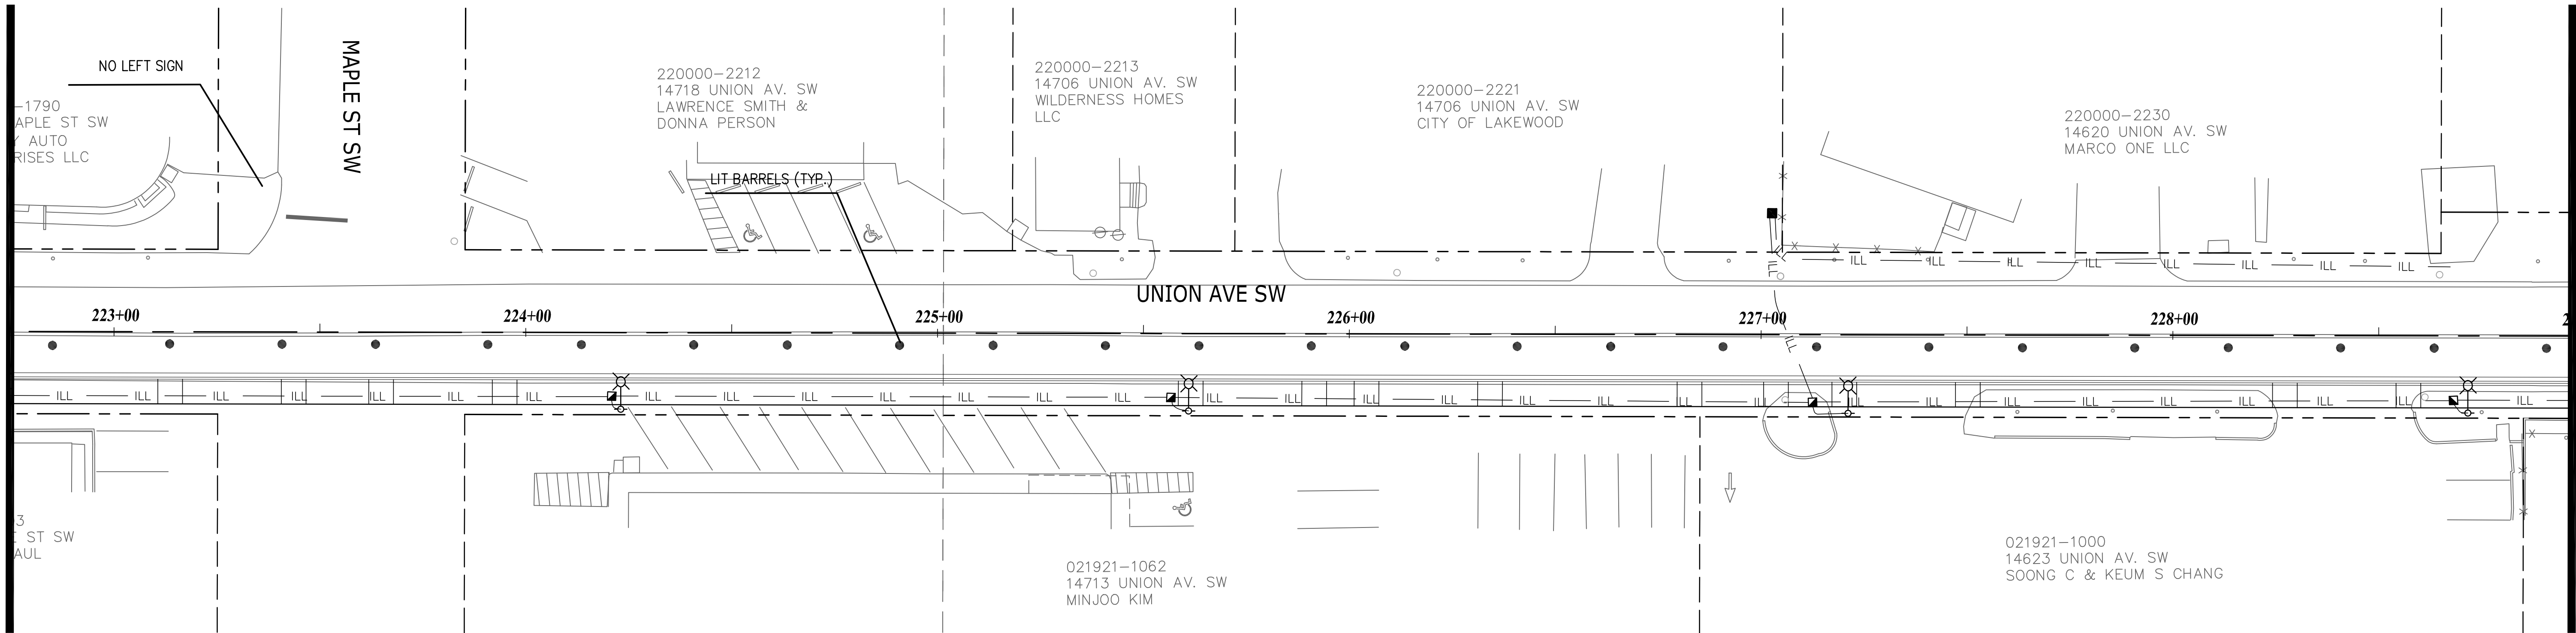

MATCH LINE STA. 229+00
SEE DRAWING TC4

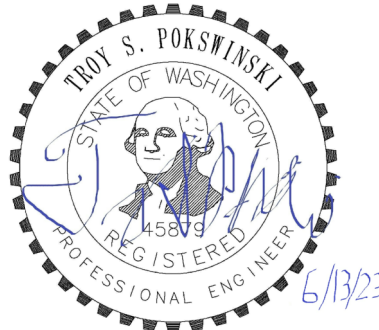No.	Release/Revision	Re. Date	Re. By	Designed By: T. POKSWINSKI	 	Project Name: UNION AVENUE SW IMPROVEMENTS	Job No. 302.0096
				Entered By: A. DOBROVIDOVA		Drawing Name:	Drawing No. TC3
				Checked By: C. T. HILL			
				Approved By: P. BUCICH			
				Project Start Date: XX/XX/23 Drawing Scale: AS SHOWN Electronic File Name: 302.0096			Sheet 19 of 20

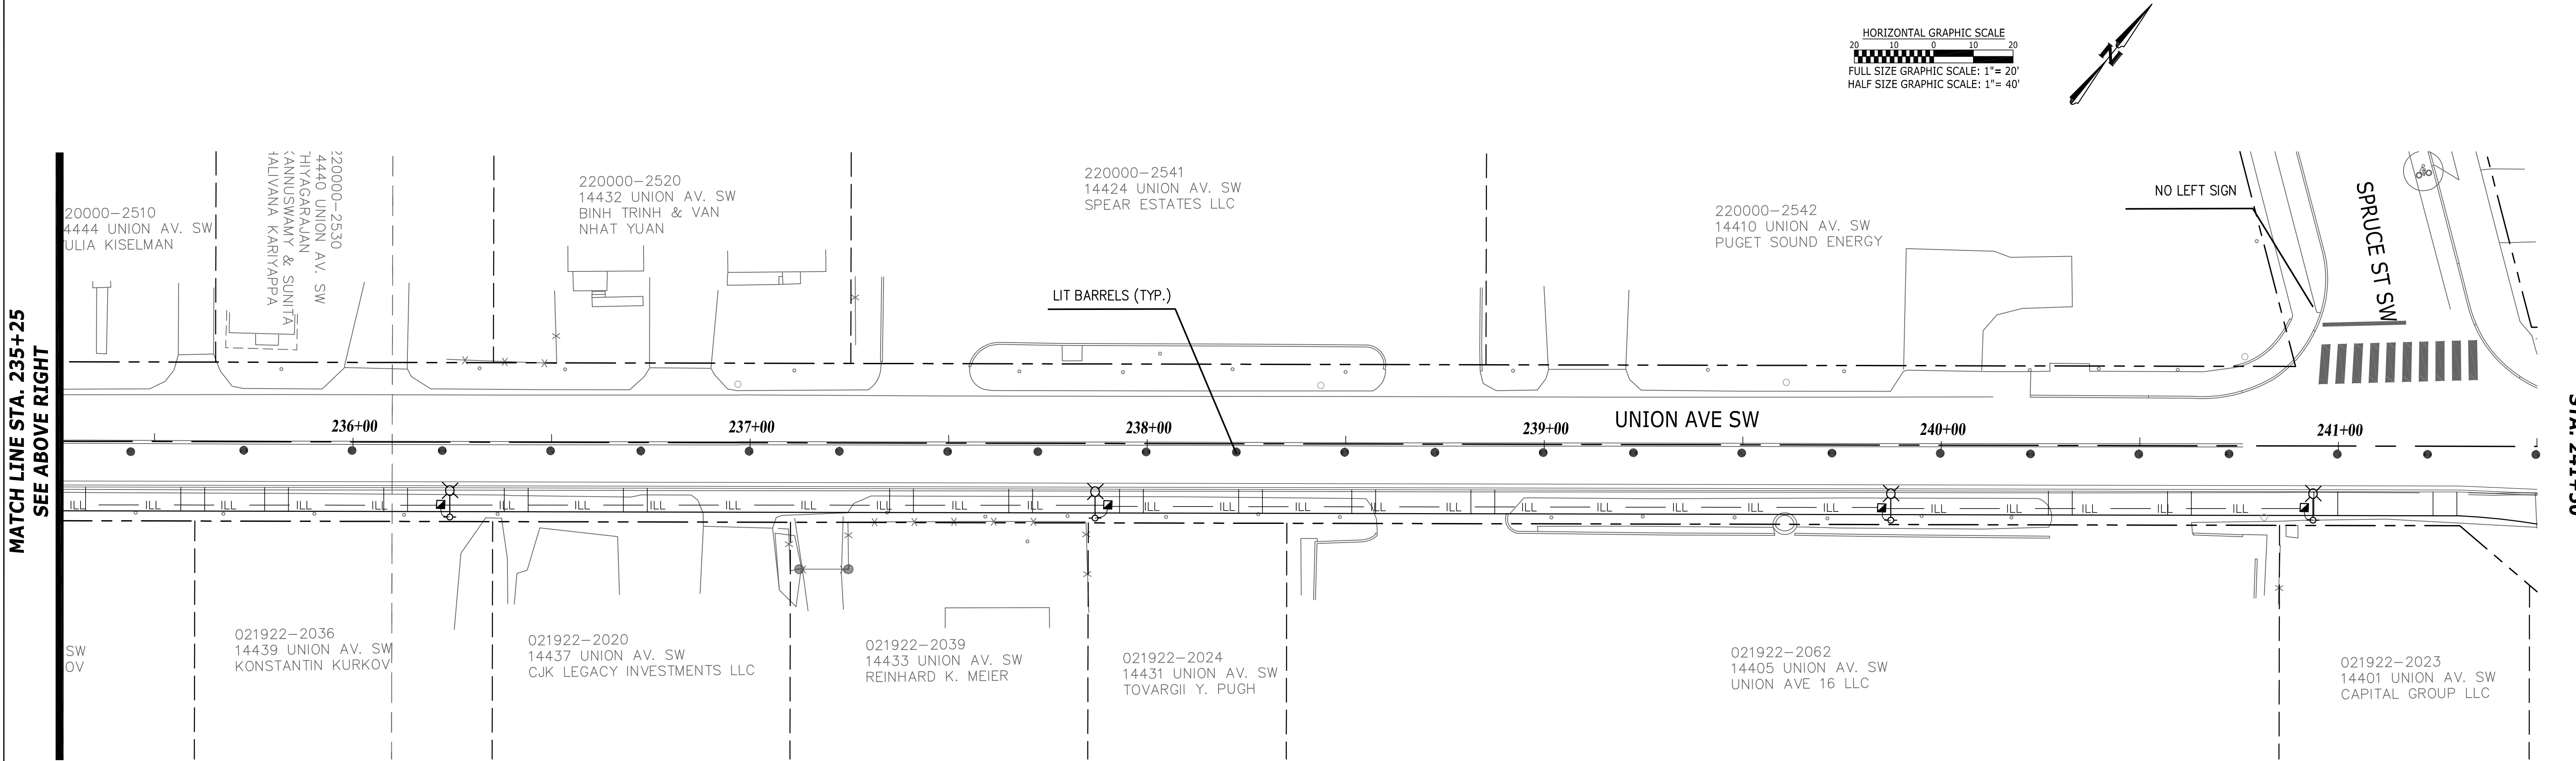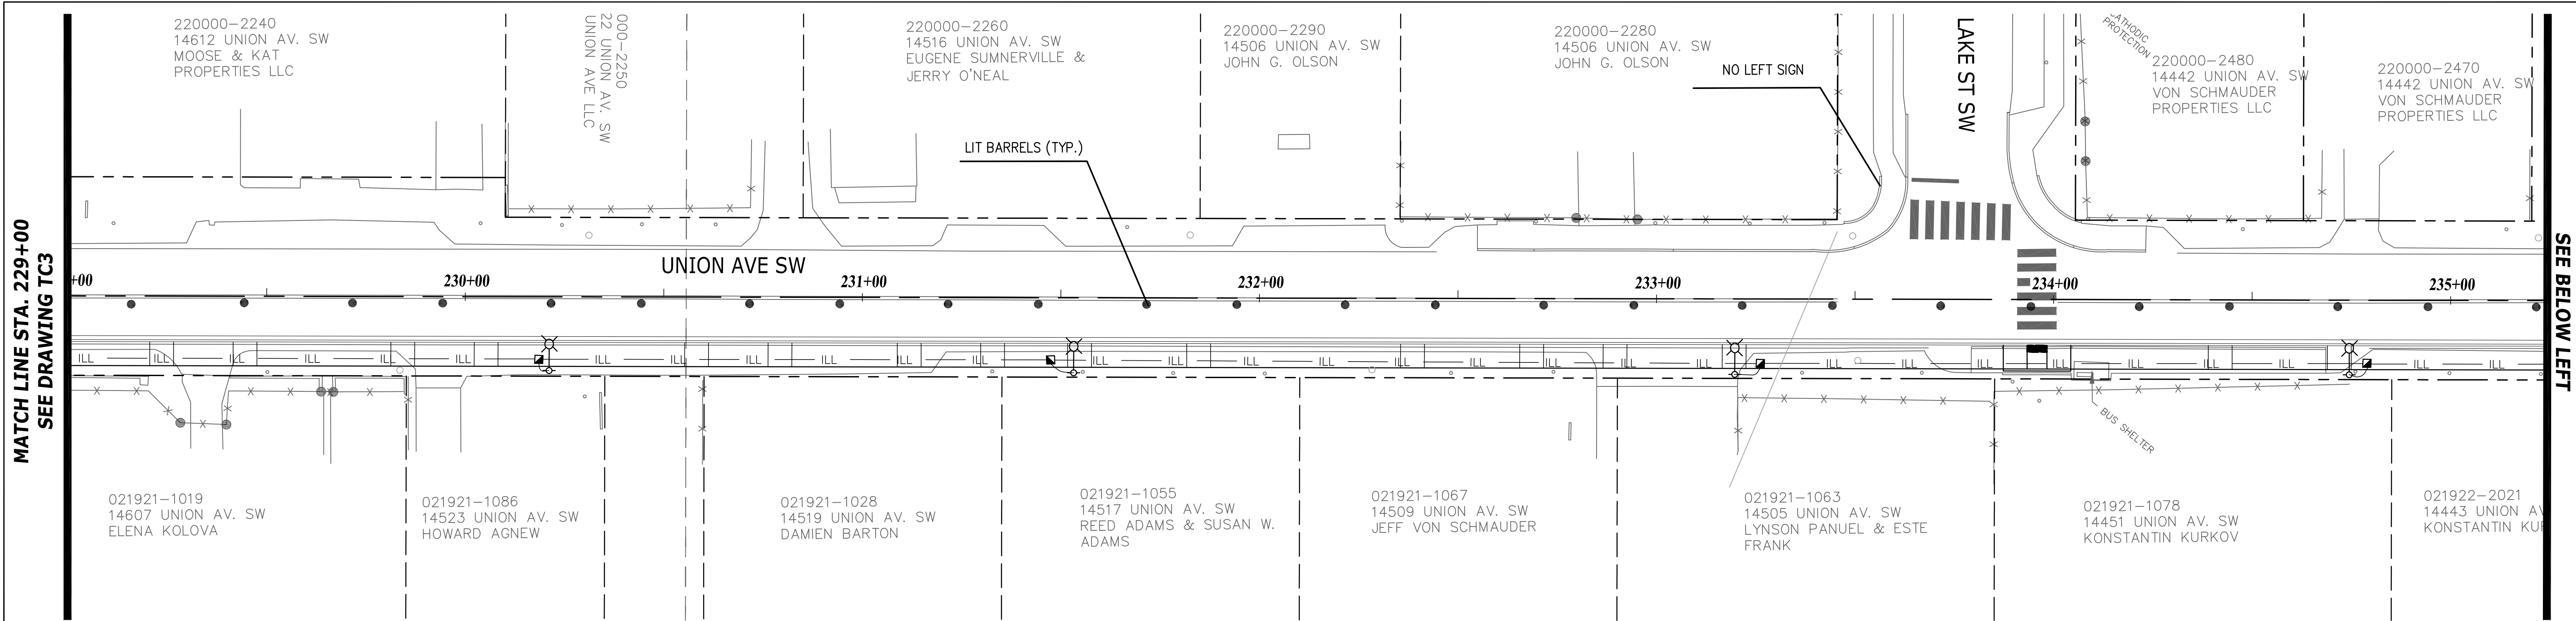

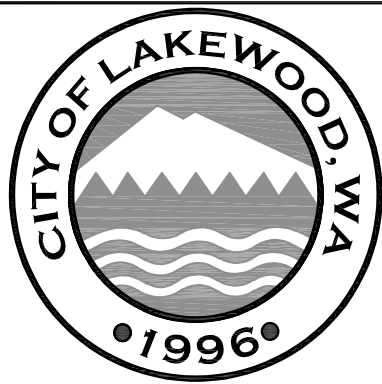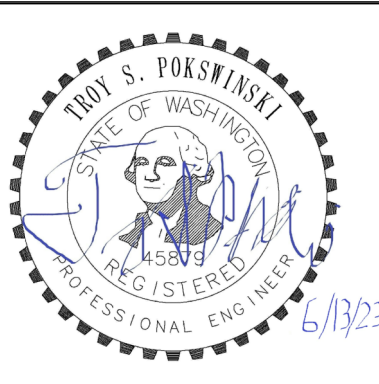No.	Release/Revision	Re. Date	Re. By	Designed By: T. POKSWINSKI			Project Name: UNION AVENUE SW IMPROVEMENTS	Job No. 302.0096
				Entered By: A. DOBROVIDOVA			Drawing Name:	Drawing No. TC4
				Checked By: C. T. HILL				
				Approved By: P. BUCICH				
				Project Start Date: XX/XX/23			TRAFFIC CONTROL PLAN - STA. 229+00 TO STA. 241+50	Sheet 20 of 20
				Electronic File Name: 302.0096				